

GENERAL CONDITIONS
UNLESS OTHERWISE NOTED, GENERAL CONDITIONS OF THE CONTRACT SHALL BE AS SET FORTH IN AIA DOCUMENT-2014/87 SHALL APPLY. THE CONTRACTOR SHALL OBTAIN CERTIFICATE OF OCCUPANCY. SUBSTITUTIONS SHOULD NOT BE MADE WITHOUT WRITTEN AUTHORIZATION BY THE ARCHITECT. THE PREMISES SHALL BE KEPT REASONABLY CLEAN AT ALL TIMES. AT THE COMPLETION OF WORK, THE CONTRACTOR SHALL REMOVE ALL WASTE MATERIALS, TOOLS, RUBBISH, ETC., CLEAN GLASS AND LEAVE WORK BROOM CLEAN UNLESS OTHERWISE SPECIFIED. THE CONTRACTOR SHALL CARRY WORKMAN'S COMPENSATION AND GENERAL LIABILITY INSURANCE. ALL SHALL COMPLY WITH STATE AND LOCAL ORDINANCES. THE CONTRACTOR SHOULD FULLY GUARANTEE HIS WORK AND THE WORK OF HIS SUBCONTRACTORS FOR A PERIOD OF ONE YEAR AFTER COMPLETION OF THE PROJECT UNLESS OTHERWISE SPECIFIED. ALL WORK SHALL BE PERFORMED IN ACCORDANCE WITH GOOD BUILDING PRACTICES. THE CONTRACTOR SHALL INDEMNIFY AND HOLD HARMLESS THE OWNER, ARCHITECT, AND THEIR AGENTS AND EMPLOYEES FROM AND AGAINST ALL CLAIMS, DAMAGES, LOSSES AND EXPENSES, INCLUDING ATTORNEYS FEES ARISING OUT OF OR RESULTING FROM THE PERFORMANCE OF THE WORK PROVIDED THAT ANY SUCH CLAIM, DAMAGE, LOSS OR EXPENSE (A) IS ATTRIBUTABLE TO INJURY, SICKNESS, DISEASE OR DEATH OR TO INJURY TO OR DESTRUCTION OF TANGIBLE PROPERTY (OTHER THAN THE WORK ITSELF INCLUDING THE LOSS OR USE RESULTING THEREFROM). (B) IS CAUSED IN WHOLE OR IN PART BY ANY NEGLIGENT ACT OR OMISSION OF THE CONTRACTOR, ANY SUBCONTRACTOR, ANYONE DIRECTLY OR INDIRECTLY EMPLOYED BY ANY OF THEM, OR ANYONE FOR WHOSE ACTS ANY OF THEM MAY BE LIABLE REGARDLESS OF WHETHER OR NOT IT IS CAUSED IN PART BY A PARTY INDEMNIFIED HEREUNDER. ALL MATERIALS, ASSEMBLIES, AND METHOD OF CONSTRUCTION INCLUDING BUT NOT LIMITED TO FORM-WORK, BLOCK-WORK, FRAMING, NAILING, PLACING OF CONCRETE, ETC. ARE TO BE CAREFULLY SUPERVISED BY THE CONTRACTOR TO BE SURE THEY ARE IN ACCORDANCE WITH THE DRAWINGS, SPECIFICATIONS, APPLICABLE CODES AND GOOD PRACTICE. DEVIATIONS FROM THE DRAWINGS AND SPECIFICATIONS WILL NOT BE TOLERATED WITHOUT WRITTEN AUTHORIZATION OF THE ARCHITECT. THE CONTRACTOR SHALL BE RESPONSIBLE FOR THE SHOP DRAWINGS WHICH MAY BE NEEDED. ALL DIMENSIONS AND CONDITIONS ARE TO BE FIELD VERIFIED. CONTRACTOR TO REMOVE & RELOCATE AS REQUIRED ALL EXISTING WORK WHICH INTERFERES WITH NEW CONSTRUCTION USE WRITTEN DIMENSIONS ONLY. DO NOT SCALE DRAWINGS FOR DIMENSIONS. IF NO DIMENSIONS ARE PROVIDED, CONSULT DESIGNER FOR CLARIFICATION PRIOR TO PROCEEDING. CONTRACTOR SHALL BE RESPONSIBLE FOR MAKING THE PROJECT WATER-TIGHT – WEATHER TIGHT NOT WITHSTANDING ANYTHING IN THE CONTRACT DOCUMENTS.

SITE WORK
STAKEOUT IS TO BE PERFORMED BY A LICENSED SURVEYOR. STAKING AND LAYOUT ARE TO ESTABLISH ALL LINES AND BENCHMARKS. VERIFY ALL GIVEN DATA ON DRAWINGS. IN CASE OF DISCREPANCY, RECEIVE CLARIFICATION FROM ARCHITECT PRIOR TO PROCEEDING. EXCAVATE AND BACK FILL FOR WORK INDICATED ON DRAWINGS. STOCKPILE TOPSOIL OBTAINED FROM STRIPPING DRIVEWAY AND BUILDING SITE. STOCKPILE ALL EXCAVATED MATERIAL. NEW AND EXISTING BACK FILL MATERIAL AND TOPSOIL ARE TO BE FREE OF WEEDS, TREE ROOTS, ROCKS AND DEBRIS. ALL SURPLUS MATERIAL THAT IS UNSUITABLE FOR BACK FILL MATERIAL SHALL BE REMOVED FROM THE SITE. PROTECT ALL TREES WITHIN EIGHT FEET OF THE BUILDING. PROPER APPROVALS MUST BE OBTAINED BEFORE COVERING ANY EXCAVATED WORK. PATIOS ARE TO BE SLOPED 1/8 TO 1/4" PER FOOT AWAY FROM RESIDENCE. PRIOR TO BEGINNING ANY EXCAVATION, CONTRACTOR SHALL VERIFY AND MARK ALL UNDERGROUND UTILITY LOCATIONS.

CONCRETE
NO CONCRETE OR MASONRY WORK SHALL BE DONE DURING TEMPERATURES OF 40 DEGREES F. AND FALLING. NO CONCRETE SHALL BE PLACED ON FROZEN SURFACES. NO ADDITIVES SHALL BE ALLOWED WITHOUT WRITTEN PERMISSION OF THE ARCHITECT ALL CONCRETE IS TO BE MIN. 3,000 P.S.I. AT 28 DAYS AND 3,500 PSI FOR GARAGE SLAB. PROVIDE ALL SLEEVES AND FOUNDATION VENTS AS REQUIRED BY LOCAL CODES. UNLESS INDICATED, ALL FOUNDATION FOOTINGS ARE TO BE A MIN. 8" DEEP PROJECTING 6" ON EACH SIDE OF THE FOUNDATION WALL. PROVIDE TWO #4 DEFORMED BARS CONTINUOUS IN THE FOOTING. ALL 4" THICK CONCRETE SLABS TO HAVE 6X6 10/10 WELDED WIRE REINFORCING. ANCHOR BOLTS IN CONCRETE SHALL BE HOOKED 5/8" X 12" AT MAX. 40" O.C. AND MAX. 12" FROM CORNERS. PROVIDE BUTTMENT EXPANSION JOINTS BETWEEN SLABS AND FOUNDATION WALLS.

GARAGES
GARAGE SEPERATION SHALL COMPLY PER FTO-13 AND BE SEPARATED FROM RESIDENCE AND ITS ATTIC AREA BY NOT LESS THAN 5/8" TYPE-X GYP. BD. APPLIED TO GARAGE SIDE. WHERE THE SEPARATION IS A FLOOR-CEILING ASSEMBLY, THE STRUCTURE SUPPORTING THE SEPARATION SHALL ALSO BE PROTECTED BY NOT LESS THAN 2 LAYERS OF 5/8" TYPE-X GYP. BD. OPENINGS BETWEEN GARAGE AND RESIDENCE SHALL BE EQUIPPED WITH SOLID WOOD DOORS NOT LESS THAN 1-3/8" IN THICKNESS, SOLID OR HONEYCOMB CORE STEEL DOORS NOT LESS THAN 1-3/8" THICK.
GARAGE APPLIANCES SHALL BE INSTALLED 18" ABOVE FLOOR ON A PLATFORM.
GARAGE FLOORS ARE TO BE SLOPED TOWARDS THE GARAGE DOOR TO FACILITATE THE MOVEMENT OF LIQUIDS.

ELECTRICAL
ALL WORK SHALL COMPLY WITH THE NATIONAL ELECTRICAL CODE AND ALL STATE, LOCAL, AND UTILITY COMPANY CODES AND REGULATIONS. ALL CIRCUITS SHALL BE MINIMUM 15 AMP. POWER WIRING SHALL BE MINIMUM 14 AWG. CONVENIENCE OUTLETS SHALL BE LOCATED 12" ABOVE FINISHED FLOOR UNLESS OTHERWISE INDICATED. ALL SWITCHED TO BE LOCATED 36" ABOVE THE FINISHED FLOOR UNLESS OTHERWISE INDICATED. SUPPLY RECOMMENDED LAMPS IN ALL FIXTURES.

FRAMING AND ROUGH CARPENTRY
JOISTS RAFTERS AND STUDS SHALL BE CONSTRUCTION GRADE DOUGLAS FIR #2 OR BETTER. ALL WOOD SILLS AND WOOD IN CONTACT WITH MASONRY SHALL BE ACQ TREATED. ALL METAL FASTENERS IN CONTACT WITH ACQ TREATED LUMBER TO BE DOUBLE HOT DIPPED GALVANIZED OR AS SPECIFIED BY MANUFACTURER. TERMITE SHIELDS AT SILL TO BE COPPER OR OTHER APPROVED NON CORROSIVE MATERIAL. ALL EXTERIOR SHEATHING SHALL BE 1/2 CDX DOUGLAS FIR PLYWOOD. SUB-FLOORS TO BE 3/4" CDX PLYWOOD. EXTERIOR SHEATHING TO BE COVERED WITH "TYVEK" HOUSE WRAP OR APPROVED EQUAL. BLOCK STUD WALLS AT 1/2 STORY HEIGHTS AND AT ALL UNSUPPORTED EDGES OF PLYWOOD. PROVIDE SOLID BLOCKING AND DIAGONAL BRACING OF FLOOR JOISTS AT 8' O.C. MAXIMUM AND SOLID BLOCKING UNDER ALL UNSUPPORTED EDGES OF PLYWOOD. ALL CAP PLATES TO BE DOUBLED AND NAILED BOTTOM CAP PLATED TO END OF STUDS. LAP CAP PLATES AT CORNERS. TOE NAIL JOISTS TO CAP OR BEAM WITH . WHERE TUSH FRAMING OCCURS, USE MIN. 16GA SHEET METAL JOISTS HANGERS BY "SIMPSON" OR APPROVED EQUAL. ALL CORNERS TO BE MINIMUM 3/2X4 STUDS. HEADERS SHALL BE MINIMUM 2/2X6 UNLESS NOTED ON PLANS. MINIMUM BEARING FOR STUDS, JOISTS AND BEAMS SHALL BE 3 1/2". USE DOUBLE JACK STUDS FOR HEADERS OVER FIVE FEET IN LENGTH. DOUBLE BLOCKING SHALL BE PROVIDED IN THE FOLLOWING AREAS:
A) CONCEALED SPACES OF STUD WALLS AT FLOOR AND CEILING LEVELS
B) SOFFITS AND FURRED SPACES AT 10 FOOT LEVELS BOTH VERT. AND HORIZ.
C) ALL INTERCONNECTIONS BETWEEN CONCEALED HORIZONTAL AND VERTICAL SPACES WHICH OCCUR AT DROP SOFFITS, CEILINGS, AND COVE CEILINGS.
D) BETWEEN STAIR STRINGERS IN BOTTOM AND TOP OF RUN, AND BETWEEN STUDS ALONG AND IN LINE WITH THE STRINGERS.
E) OPENINGS AROUND DUCTS, PIPES, VENTS AND CHIMNEYS WITH NON-COMBUSTIBLE MATERIALS.

PLUMBING
CONTRACTOR SHALL INSTALL WATER SUPPLY AND SANITARY SYSTEM AS INDICATED AND AS PER THE NATIONAL STANDARD PLUMBING CODE. PROVIDE HOT AND COLD SHUT-OFF VALVES AT ALL FIXTURES. ALL WATER PIPING TO HAVE CLEANOUTS AT ALL CHANGES OF DIRECTION AND AT BASE OF VERTICAL WASTES. USE 4" CAST IRON THROU RH FOUNDATION WALL PITCHED MIN. 1/8" PER FOOT. TRAP WASTE SIZES FOR FIXTURES SHALL BE AS FOLLOWS:
DISH WASHER 1 1/2"
KITCHEN SINK 1 1/2"
LAVATORY 1 1/4"
SHOWER 2"
TOILET 3"/MATCH FIXTURE OUTLET
ALL SYSTEMS TO HAVE ONE 3" MAIN VENT STACK INCREASED TO 4" THROUGH THE ROOF. PROVIDE FROSTPROOF HOSE-BIBS AS INDICATED ON PLANS WITH EASILY ACCESSIBLE DRAIN DRAIN-COCKS. THE WATER SUPPLY AND SEWAGE DISPOSAL SYSTEM SHALL COMPLY TO THE APPLICABLE COUNTY DEPARTMENT OF HEALTH STANDARDS AND REGULATIONS. APPROVAL OF ALL PLUMBING MUST BE OBTAINED FROM APPROPRIATE LOCAL AUTHORITIES PRIOR TO CONCEALMENT. PRIOR TO ORDERING, CONTRACTOR SHALL SUPPLY CUTS OF FIXTURES FOR OWNERS APPROVAL. IN THE EVENT THAT THE OWNER CHANGES, THE CONTRACTOR SHALL CREDIT THE OWNER FOR THE FULL SUBCONTRACTORS COST FOR THE CHANGED UNIT.

INTERNATIONAL ENERGY CONSERVATION CODE
AIR LEAKAGE
-JOINTS, PENETRATIONS, AND ALL OTHER SUCH OPENINGS IN THE BUILDINGS ENVELOPE THAT ARE SOURCES OF AIR LEAKAGE MUST BE SEALED.
-RECESSED LIGHTS MUST BE TYPE 1 C RATED AND INSTALLED WITH NO PENETRATIONS, OR TYPE 1 C OR NON-1 C RATED INSTALLED INSIDE AN APPROPRIATE AIR-TIGHT ASSEMBLY WITH 0.5" CLEARANCE FROM COMBUSTIBLE MATERIALS AND 3" CLEARANCE FROM INSULATION

VAPOR RETARDER:
-REQUIRED ON THE WARM-IN-WINTER SIDE OF ALL NON-VENTED FRAMED CEILINGS, WALLS, AND FLOORS.
MATERIALS IDENTIFICATION:
-MATERIALS AND EQUIPMENT MUST BE INSTALLED IN ACCORDANCE WITH THE MANUFACTURER'S INSTALLATION INSTRUCTIONS.
-MATERIALS AND EQUIPMENT MUST IDENTIFIED SO THAT THE COMPLIANCE CAN BE DETERMINED.
-MANUFACTURER MANUALS FOR ALL INSTALLED HEATING AND COOLING EQUIPMENT AND SERVICE WATER HEATING EQUIPMENT MUST BE PROVIDED.
-INSULATION R-VALUES AND GLAZING U-FACTORS MUST BE CLEARLY MARKED ON THE BUILDING PLANS OR SPECIFICATIONS.

TEMPERATURE CONTROLS:
-EACH DWELLING UNIT HAS AT LEAST ONE THERMOSTAT CAPABLE OF AUTOMATICALLY ADJUSTING THE SPACE TEMPERATURE SET POINT OF THE ZONE.

STAIRS/GUARDS
STAIRWAYS SHALL BE NOT LESS THAN 36 INCHES IN CLEAR WIDTH AT ALL POINTS ABOVE THE PERMITTED HANDRAIL HEIGHT.
HEADROOM SHALL BE A MIN. OF 6 FEET 8 INCHES MEASURED VERTICALLY FROM THE SLOPED LINE ADJOINING THE TREAD NOSING.
STAIR RISER HEIGHT SHALL BE A MAXIMUM OF 8-1/4 INCHES. STAIR TREAD DEPTH SHALL BE A MIN. OF 9 INCHES. ALL TREADS AND RISERS ARE TO BE UNIFORM IN HEIGHT AND DEPTH.
STAIR PROFILE, STAIRS WITH A TREAD DEPTH OF LESS THAN 11 INCHES ARE REQUIRED TO HAVE A NOSING OF BETWEEN 3/4 AND 1-1/4 INCHES.
LANDINGS FOR STAIRS, THERE SHALL BE A LANDING AT THE TOP AND BOTTOM OF EACH STAIRWAY, AND BE A MIN. OF 36 INCHES MEASURED IN THE DIRECTION OF TRAVEL.
HANDRAILS SHALL COMPLY PER IRC R311.7.7 HANDRAILS SHALL BE PROVIDED ON AT LEAST ONE SIDE OF STAIRS AND SHALL BE 30" - 38" IN HEIGHT MEASURED VERTICALLY FROM THE NOSING OF THE TREADS.
GUARDS SHALL BE PROVIDED ALONG OPEN-SIDED WALKING SURFACES THAT ARE LOCATED MORE THAN 30 INCHES ABOVE THE FLOOR OR GRADE BELOW. GUARDS SHALL BE NOT LESS THAN 36 INCHES IN HEIGHT.

WOOD FLOORING
WOOD FLOORING TO BE 2 1/4" WIDE BY 3/4" THICK CONSTRUCTION GRADE DOUGLAS FIR #2 OR BETTER. MINIMUM 2" IN LENGTH. FLOORING SHALL BE INSTALLED OVER CONSTRUCTION WEIGHT CRAFT PAPER. ALL BOARDS TO BE BLIND NAILED WITH 2" BARRED FASTENERS. ALL JOINTS TO BE TIGHT WITH BOARD EDGES FREE OF DEFORMITIES. ALLOW FOR PERIMETER EXPANSION AS RECOMMENDED BY WOOD FLOOR MANUFACTURER. PREPARATION AND FINISHING:
ALL PLANK FLOORING TO BE SANDED THREE TIMES; ONE COURSE CUT, ONE MEDIUM CUT, AND ONE FINE CUT. ALL SANDING TO BE UNIFORM, SWIRLS AND CROSS-MARKS ARE UNACCEPTABLE. TWO COATS OF STAIN, APPROVED BY THE ARCHITECT AND/OR OWNER SHALL BE APPLIED IN A UNIFORM MANNER. FLOORING SHALL BE SEALED WITH TWO COATS OF NON-YELLOWING POLYURETHANE AS MANUFACTURED BY MCKLUSKY'S HEIRLOOM SERIES, EGGSHELL FINISH OR APPROVED EQUAL.


PAINTING AND STAINING
THE FOLLOWING IS INCLUDED FOR THE CONVENIENCE OF THE PAINTING CONTRACTORS AND ONLY AS AN INDICATION OT THE TYPES OF PAINTS REQUIRED FOR VARIOUS SURFACES. IT IS THE INTENT OF THESE SPECIFICATIONS TO PROVIDE A COMPLETE FINISH. ALL PAINTED SURFACES MUST BE FULLY COVERED IN A UNIFORM MANNER TO BE ACCEPTABLE.
INTERIOR WOOD SURFACES-APPLY TO LIGHTLY SANDED SURFACES, WALLS, DOORS, FRAMES, TRIM, AND BASES. ONE COAT WOOD FILLER OR STAIN AND TWO COATS MCKLUSKY'S EGGSHELL FINISH NON-YELLOWING POLYURETHANE.
GYPSUM BOARD- MINIMUM ONE COAT PRIMER AND TWO COATS FLAT PAINT.
EXTERIOR WOOD SURFACES- TWO COATS EXTERIOR GRADE STAIN.
EXTERIOR EXPOSED METAL- MINIMUM ONE COAT ZINC CHROMATE AND TWO COATS EXTERIOR ENAMEL.
ALL MATERIAL SHALL BE OF BEST QUALITY PITTSBURGH, PRATT & LAMBERT, DUTCH BOY. CABOTS, MCKLUSKYS, OR APPROVED EQUAL. CONTRACTOR IS TO PROVIDE SAMPLES OF ALL PAINTS AND STAINS FOR ARCHITECTS AND/OR OWNERS APPROVAL.

GYPSUM WALL BOARD
INSTALLED AS PER SECTION R702.3 OF THE INTERNATIONAL RESIDENTIAL CODE. GYPSUM WALLBOARD APPLICATION SHALL BE TAPE JOINT SYSTEM. ALL GYPSUM BOARD TO BE 1/2" ON WALLS AND 1/2" ON CEILINGS UNLESS OTHERWISE INDICATED. FINISH JOINTS, J-BEADS, NAIL DIMPLES, CORNERS AND EDGES SHALL BE TAPED AND RECEIVE THREE COATS OF JOINT COMPOUND. ALLOW 24 HOURS TO DRY BETWEEN COATS. FINAL COAT TO BE SANDED SMOOTH. METAL CORNER BEAD TO BE USED ON ALL OUTSIDE CORNERS AND AROUND ALL OPENINGS.
ALL BATHROOMS SHALL BE PROVIDED WITH MOISTURE RESISTANT GYPSUM BOARD.
ALL TUBS & SHOWER ENCLOSURES TO RECEIVE TILE SHALL BE PROVIDED WITH CEMENT BACKER BOARD OR APPROVED EQUAL.

GLASS WINDOWS AND DOORS
TO BE INSTALLED AS PER THE INTERNATIONAL RESIDENTIAL CODE. ALL GLASS IS TO BE INSULATED LOW-E UNLESS OTHERWISE SPECIFIED. GLASS SUBCONTRACTOR SHALL NOT INSTALL GLASS UNTIL PROPER CLEARANCES ARE PROVIDED. ALL SLIDING GLASS DOORS, SKYLIGHTS AND/OR WINDOWS AS REQUIRED BY CODE, SHALL BE INSULATED TEMPERED GLASS. ALL GLASS DOORS AND WINDOWS SHALL BE INSTALLED IN STRICT ACCORDANCE WITH THE MANUFACTURERS SPECIFICATIONS. ALL WINDOWS ARE TO BE CAULKED AND SEALED AS PER IECC ENERGY REQUIREMENTS. PROVIDE FLASHING PANS UNDER ALL SLIDER, DOORS, AND WINDOWS WITHIN A 6" OF AN EXTERIOR SURFACE. ALL EXTERIOR DOORS ARE TO BE FULLY WEATHER-STRIPPED. PROVIDE ALL SCREENS AND HARDWARE AS REQUIRED. ALL GLASS IS TO BE FREE OF SCRATCHES AND IMPERFECTIONS AND GUARANTEED BY THE MANUFACTURER FOR A PERIOD OF NO LESS THAN 5 YEARS. ALL WINDOWS TO BE ANDERSEN UNLESS INDICATED OTHERWISE. WINDOWS USED FOR RESCUE OR ESCAPE SHALL HAVE A MIN. NET CLEAR OPENABLE AREA OF 5.7 SQ. FT. MIN. WIDTH = 20 INCHES MIN. HEIGHT = 24 INCHES/ WINDOW SILL HEIGHT = MAX 44 INCHES
SAFETY GLASS SHALL BE PER IRC R308.4 AND PROVIDED WERE GLASS IS LOCATED IN HAZARDOUS AREAS AND ALL GLASS WITHIN 18" OF FLOOR.
EXCEPTIONS:
1) DOORS AND ENCLOSURES FOR BATHTUBS AND SHOWERS AND IN ANY PORTION OF A BUILDING WALL ENCLOSES THESE COMPARTMENTS WHERE THE BOTTOM EXPOSED EDGE OF THE GLAZING IS LESS THAN 60 INCHES ABOVE A STANDING SURFACE AND DRAIN INLET.
2) FIXED OR OPERABLE PANELS ADJACENT TO A DOOR WHERE THE NEAREST EDGE OF THE DOOR IN A CLOSED POSITION AND WHERE THE BOTTOM EXPOSED EDGE OF THE GLAZING IS LESS THAN 60 INCHES ABOVE THE WALKING SURFACE.
ROOMS THAT ARE HABITABLE SHALL BE PROVIDED WITH A GLAZING AREA NOT LESS THAN 8% WITH A MINIMUM OPENABLE AREA TO EXTERIOR OF 4% BASED ON THE FLOOR AREA BEING VENTILATED PER IRC R303.1 AND R303.2.

ASPHALT ROOF SHINGLES
INSTALLED AS PER SECTION R905.2 OF THE INTERNATIONAL RESIDENTIAL CODE. ALL SLOPED ROOF SHINGLES SHALL BE GAF-CLASS A ASPHALT ROOF SHINGLES OR APPROVED EQUAL. SHINGLES SHALL BE APPLIED OVER 15# ASPHALT FELT WITH GAF-WEATHER-WATCH ICE AND WATER BARRIER APPLIES AT EAVES, VALLEYS AND FLASHING. ROOFING CONTRACTOR TO PROVIDE ALL FLASHING. NECESSARY FOR A WATERTIGHT, WEATHERPROOF JOB. ROOFING IS TO BE APPLIED IN STRICT ACCORDANCE WITH THE MANUFACTURES SPECIFICATIONS. CONTRACTOR SHALL SUPPLY COLOR SAMPLES OF THE SHINGLES FOR OWNER'S APPROVAL, PRIOR TO INSTALLATION.

INSULATION
ALL EXTERIOR WALLS AND ROOFS SHALL BE INSULATED WITH KRAFT FACED FIBERGLASS BATT INSULATION BY JOHN MANVILLE OR APPROVED EQUAL. KRAFT TO BE PLACED TOWARD WARM SIDE. PROVIDE 1-1/2" RIGID FOAM INSULATION ON ALL EXTERIOR FOUNDATION WALLS FROM FOOTING TO 6" BELOW FINISHED GRADE UNLESS OTHERWISE SPECIFIED. CARE SHOULD BE TAKEN NOT TO DAMAGE FOUNDATION WATERPROOFING.

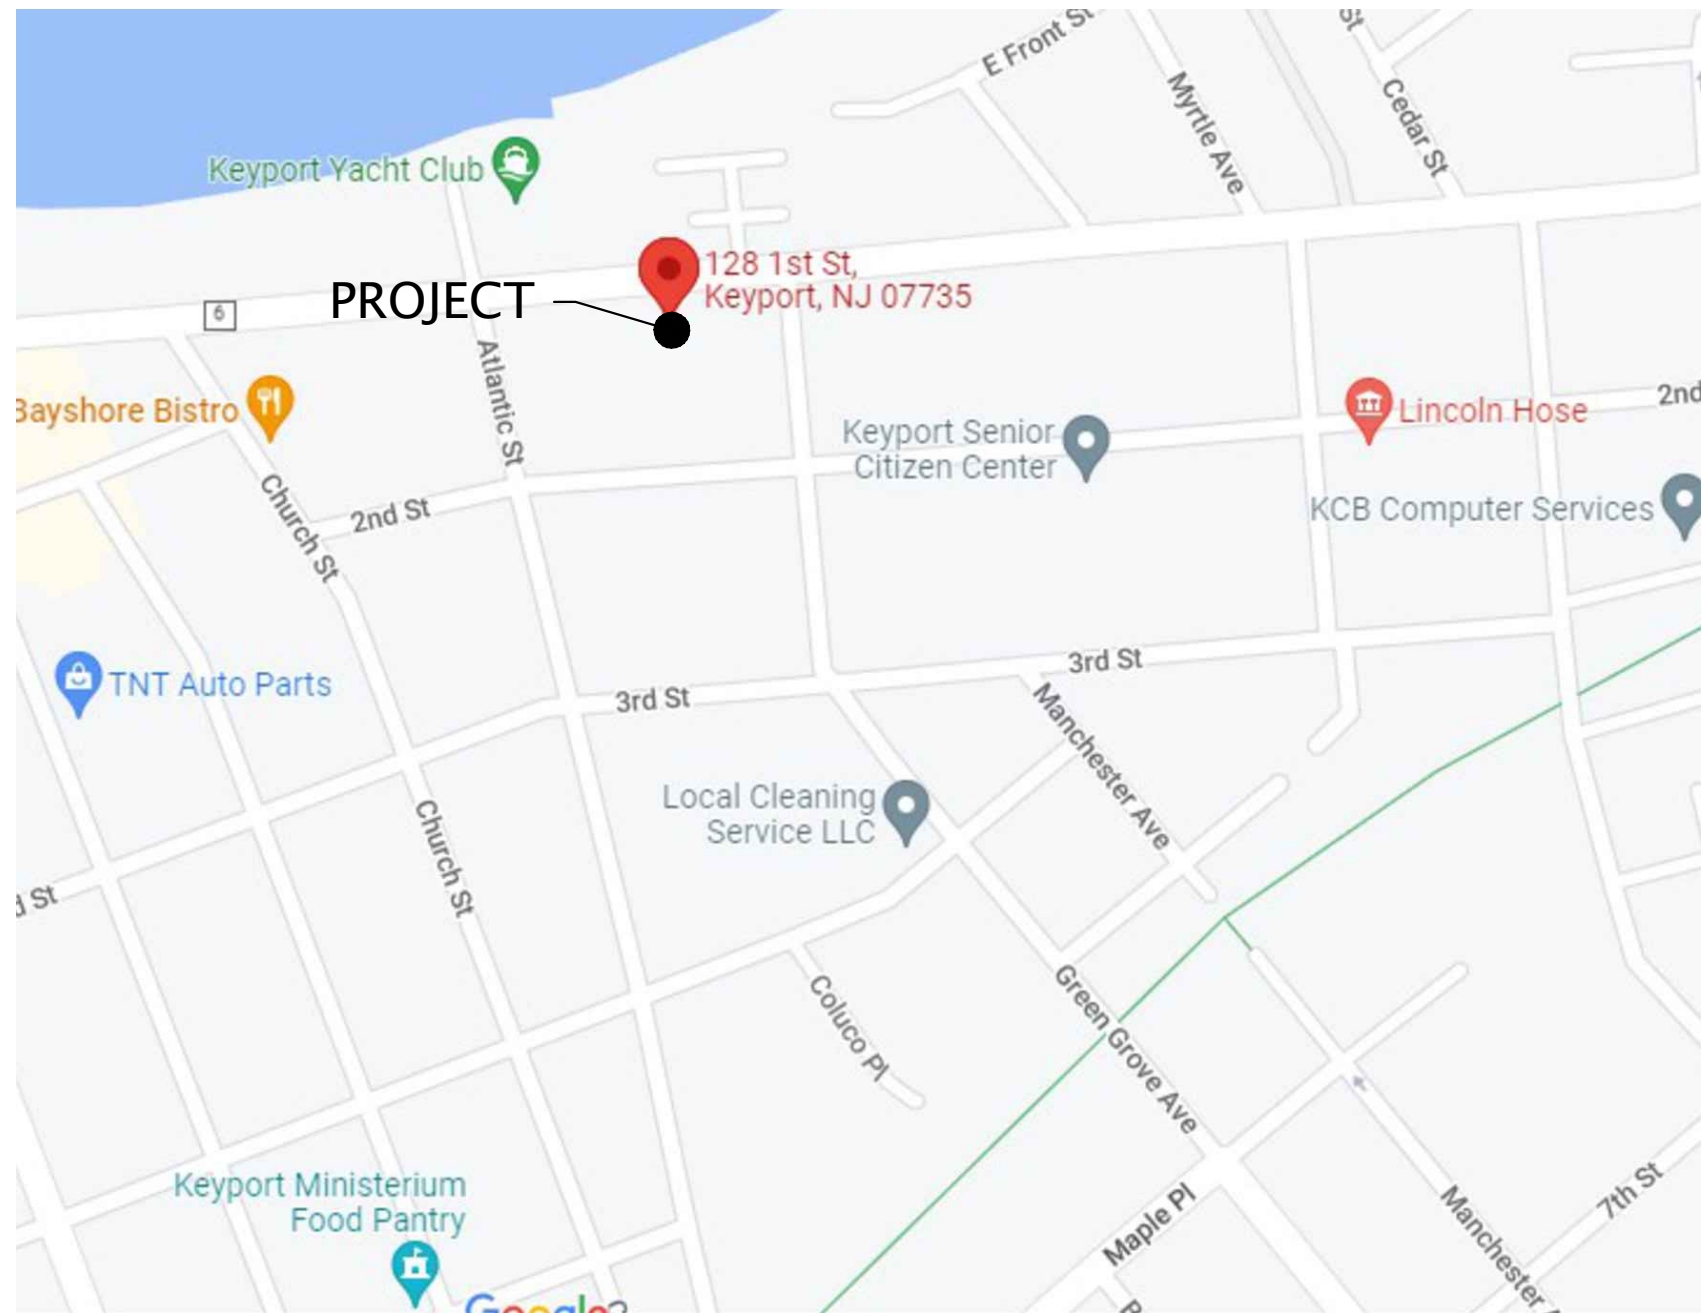


LOCATION MAP

NOT TO SCALE

ABBREVIATIONS

DESCRIPTION	ABBREVIATION	DESCRIPTION	ABBREVIATION	DESCRIPTION	ABBREVIATION
ABOVE FINISH FLOOR	A.F.F.	FEMININE NAPKIN DISPENSER	F.N. DISP.	PRESSURE & TEMP. RELIEF	P.T.R.
ACOUSTICAL TILE	A.C.T.	FIBERGLASS	F.GLASS	QUARRY TILE	Q.T.
AGGREGATE BASE COURSE	ABC	FINISH FLOOR ELEVATION	F.F.E.	REFLECTED	R.F.
ASPHALTIC CONCRETE	A.C.	FIREPROOFING	F.P.	REFLECTED CEILING PLAN	R.C.P.
AIR CONDITIONER	A/C	FIXTURE UNIT	F.U.	REGISTER	REG.
AIR HANDLING UNIT	A.H.U.	FLOOR DRAIN	F.D.	RETURN AIR GRILLE	R.A.G.
ANCHOR	ANCH.	FLUE THRU ROOF	FTR.	RISER	R.
ANCHOR BOLT	A.B.	FOUNDATION	FDN.	ROOFING	R.O.
AND	AND.	FURNISHED BY OTHERS	F.B.O.	ROUGH OPENING	R.O.
ANODIZED	ANOD.	GALVANIZED IRON	G.I.	ROUGH OPENING	R.O.
BEAM	B.E.	GENERAL	G.	ROUGH OPENING	R.O.
BEARING	BKG.	GLASS / GLAZING	GL.	RUBBER	RUB.
BENCHMARK	B.M.	GLU-LAM BEAM	G.L.B.	SANITARY NAPKIN DISPOSAL	S.N.D.
BOARD	BD.	GYPSUM WALL BOARD	G.W.B	SANITARY NAPKIN VENDOR	S.N.
BOTTOM	BTM.	HANDICAPPED	H.		
BOTTOM OF BEAM	B.O.B.	HANGER	HGR.	SAW-CUT JOINT	S.J.
BOTTOM OF JOIST	B.O.J.	HARDBOARD	HBDB.	SEPARATION	SEP.
BOTTOM OF LEDGER	B.O.L.	HARDWARE	HDWR.	SERWER	S.
BREAKER	BKR.	HARDWOOD	HDWD.	SHEATHING	SHTG.
BRONZE	BRZ.	HEADER	HDR.	SHEET METAL	S.M.
BUILT-UP ROOFING	B.U.R.	HIGHT	HT.	SH	SH.
CABINET	CAB.	HOLLOW CORE	H.C.	SLIDING GLASS DOOR	S.G.
CAPACITY	C.P.	HOLLOW METAL	H.M.	DOOR	D.
CAST IRON	C.I.	HOSE BIB	H.B.	SOAP DISPENSER	S.D.
CEILING DIFFUSER	C.D.	HOT WATER	H.W.	SOLID CORE	S.C.
CERAMIC	CER.	HOT WATER RETURN	H.W.R.	SOUNDPROOF	SP.
CERAMIC TILE	C.T.	INSIDE DIAMETER	I.D.	STAINLESS STEEL	S.S.
CLEAR OUT	C.O.	INTERMEDIATE	INT.	STEEL	STL.
CLEARANCE	CLR.	JOINT	JT.	STYROFOAM	STYRO.
COLD WATER	C.W.	JOIST	JO.	SUPPLY AIR REGISTER	SAR.
COLUMN	COL.	LAMINATE	LAM.	SUSPENDED	SUSP.
COMPACTED	COMP.	MASONRY CONTROL JOINT	M.C.J.	SYSTEM	SYS.
CONCRETE	CONC.	MATERIAL	MAT'L	THERMOSTAT	THERM.
CONCRETE MASONRY UNIT	C.M.U.	MEDIUM DENSITY FIBERBOARD	M.D.F.	TOILET PAPER DISPENSER	T.P. DISP.
CONDITION	CND.	MOISTURE	M.	TONGUE & GROOVE	T. & G.
CONDUIT THRU ROOF	C.T.R.	METAL	MTL.	TOP OF BEAM	T.O.B.
CONTROL JOINT / CONSTRUCTION JOINT	C.J.	NATURAL	NAT.	TOP OF CONCRETE / CURB	T.O.C.
CORNER GUARD	C.G.	NOT IN CONTRACT	N.I.C.	TOP OF JOIST	T.O.J.
CORRIDOR	CORR.	NOT TO SCALE	N.T.S.	TOP OF LEDGER	T.O.L.
CMP	CMP	ON CENTER	O.C.	TOP OF MASONRY	T.O.M.
C.F.FLASH.	C.F.	OPENING	OPNG.	TOP OF PLATE	T.O.P.
COUNTERSINK	C.S.	NECESSARY FOR A WATERTIGHT, WEATHERPROOF	N.F.W.	TOP OF WALL	T.O.W.
CUBIC FEET	C.F.	OUTSIDE DIAMETER	O.D.	TREAD	T.
CUBIC FEET PER MINUTE	C.F.P.M.	OVERFLOW ROOF DRAIN	O.R.D.	UNLESS NOTED OTHERWISE	U.N.O.
DAMP-PROOFING	D.P.	O' HANG	O' HANG	URINAL	UR.
DECOMPOSED GRANITE	D.G.	OVERHEAD	O.H.	VENT	V.
DISP.	DISP.	PAINTED	PTD.	VENT THRU ROOF	V.T.R.
DOUBLE	D.C.W.	PAPER TOWEL DISPENSER	P.T. DISP.	VERT.	V.
DOWN	DN.	PARTITION	PART'N	VINYL COMPOSITION TILE	V.C.T.
DRAINING FOUNTAIN	D.F.	PER LINEAR FOOT	P.L.F.	VINYL WALL FABRIC	V.W.F.
DUCT THRU ROOF	D.T.R.	PITCH POCKET	P.P.	W.	W.
DUCT THRU WALL	D.T.W.	PLASTER	PL.	WASTE RECEPTACLE	W.R.
ELECTRIC WATER COOLER	E.W.C.	PLASTIC LAMINATE	PL. LAM.	WATER CLOSET	W.C.
EXHAUST	E.X.	PLYWOOD	PLYWD.	WATER HEATER	W.H.
EXHAUST GRILLE	E.G.	PT	PT	WATERPROOF	W.P.
EXPANSION JOINT	E.X.J.	POLY VINYL CHLORIDE	P.V.C.	WATER RESISTANT	W.R.
EXTINGUISHER	E.X.T.	POST INDICATOR VALVE	P.I.V.	WELDED WIRE FABRIC	W.W.F.
FAB.	FAB.	POUNDS PER SQUARE INCH	P.S.I.	WOOD	WDW.
FABRICATED	FAB.	PRE-FABRICATED	PRE-FAB.		
FACIAL TISSUE DISPENSER	F.T. DISP	WROUGHT IRON	W.I.		
FAN COIL UNIT	F.C.U.				

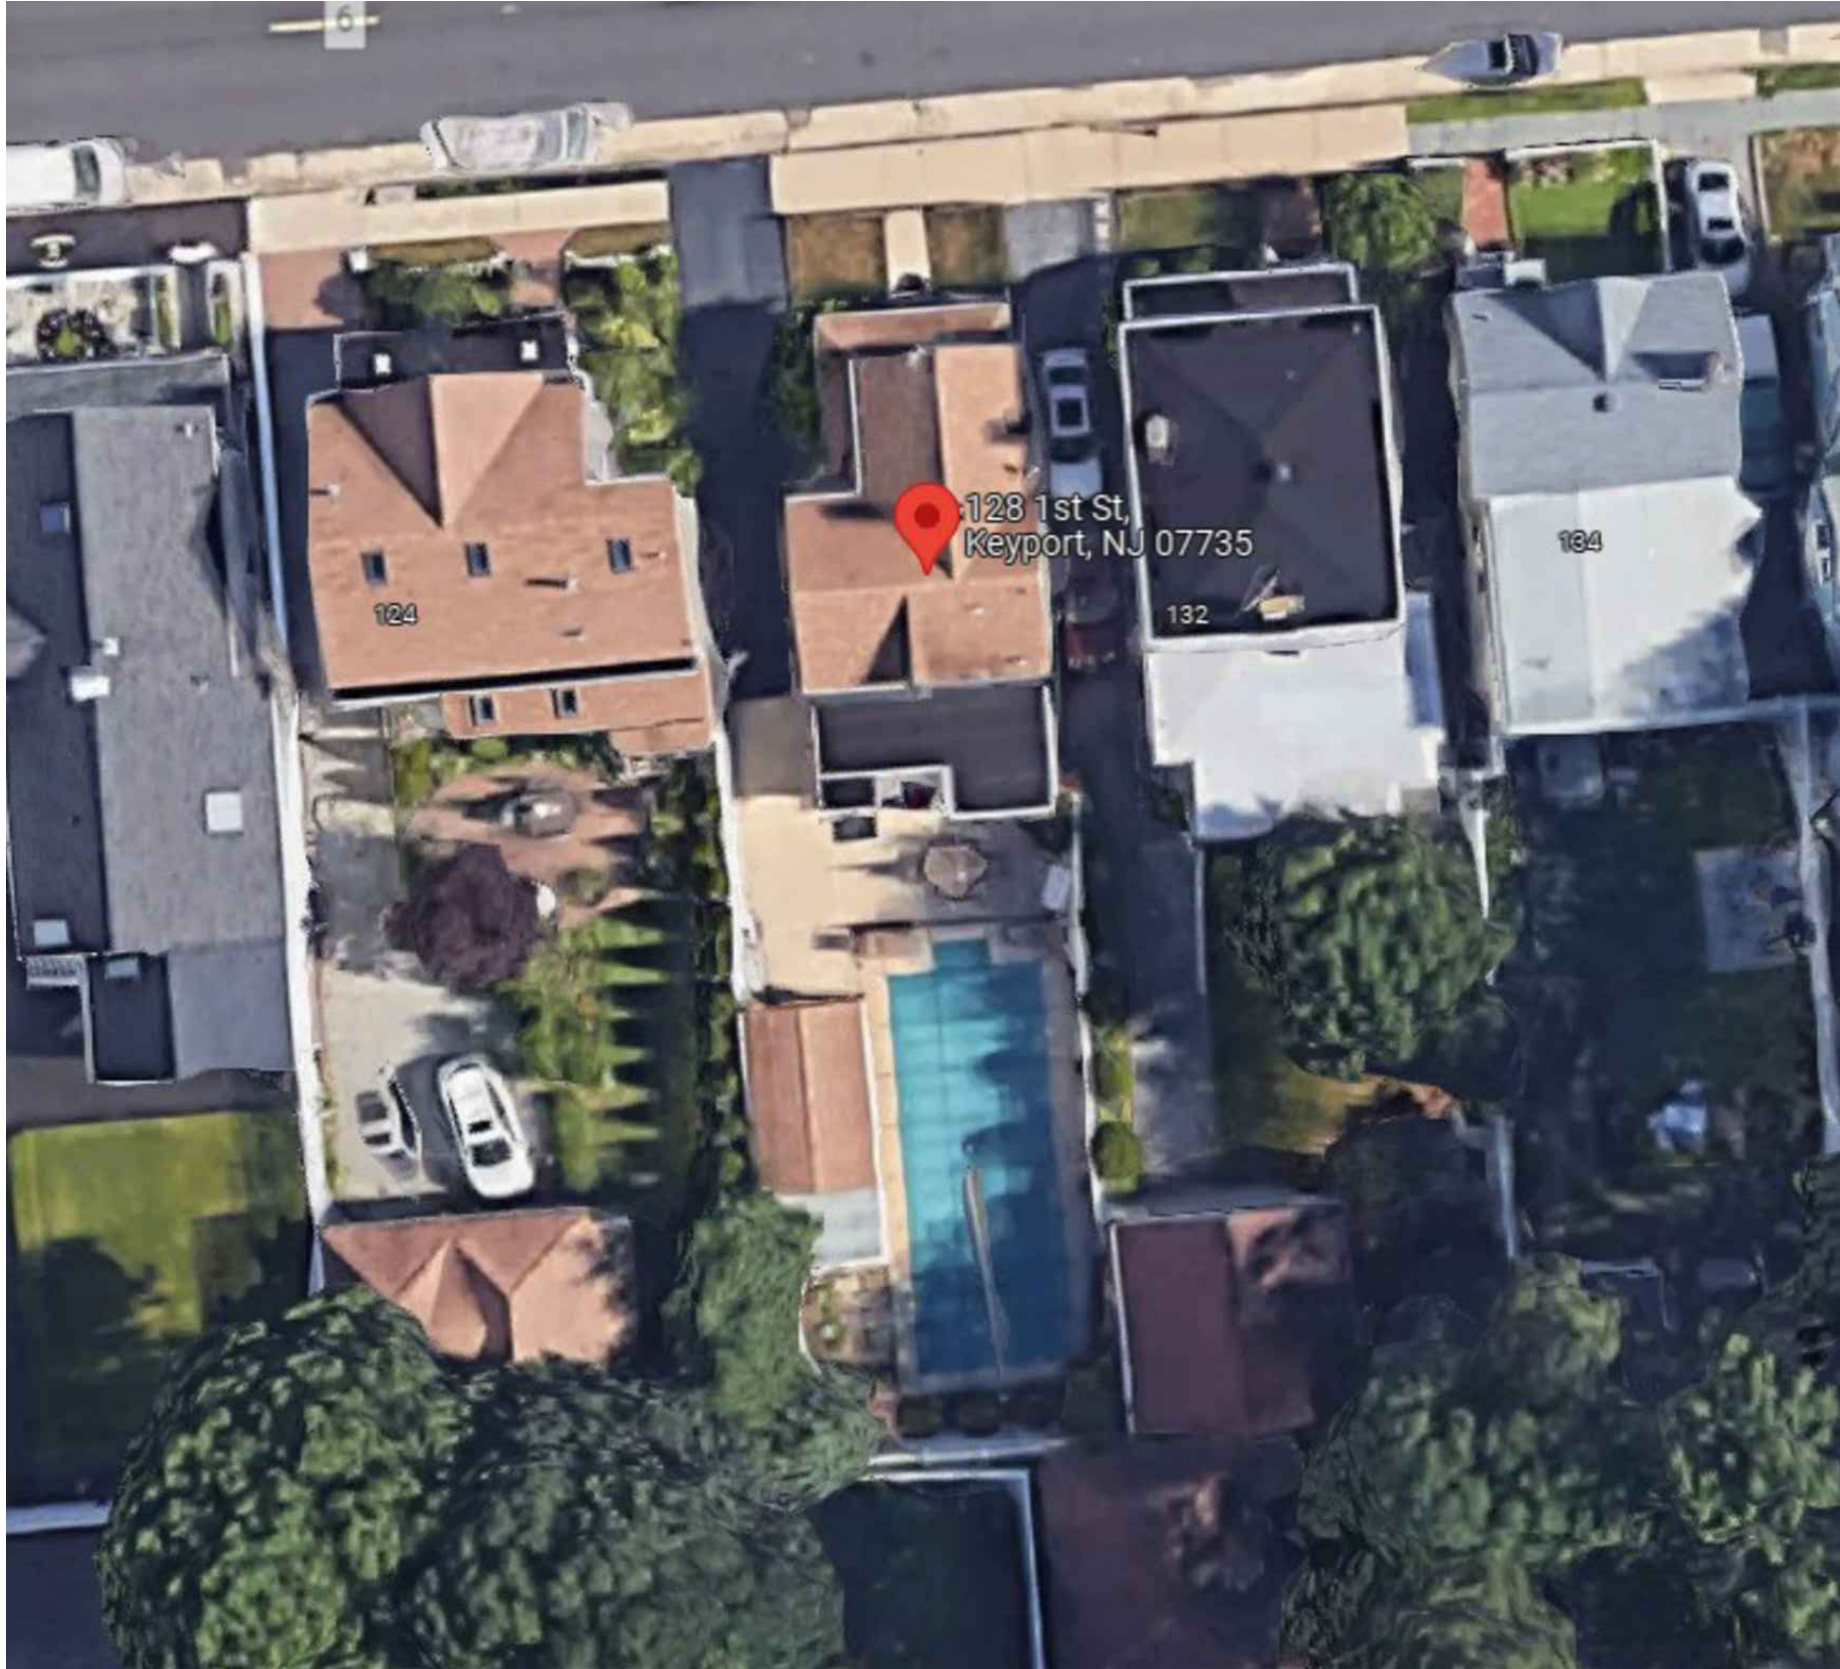

AERIAL VIEW

SCALE = NTS

CODE REVIEW

BUILDING - ICC, IBC - NJ EDIT. 2018

ONE & TWO FMLY - ICC, IRC - NJ EDIT. 2018

ELECTRIC - (NFPA 70), NEC - 2017

PLUMBING - NSPC - 2018

ENERGY (RES.D.) - ICC, IECC - 2018

ENERGY (COMM.) - ASHRAE 90.1-2016

MECHANICAL - ICC, IMC - 2018

FUEL GAS - ICC, IFGC - 2018

REHABILITATION SUBCODE - 5:23-6

ELEVATOR SUBCODE - 5:23-12

DRAWING INDEX

A-1 COVER SHEET/INDEX/SITE PLAN

A-2 FOUNDATION PLAN / DETAILS

A-3 1ST & 2ND FLOOR PLANS / DETAILS

A-4 ELECTRIC PLANS & RISERS

A-5 ELEVATIONS

DESIGN LOADS

WIND LOAD = 115 MPH

SNOW LOAD = 25 PSF

LIVE LOAD (TYPICAL) = 40 PSF

LIVE LOAD (SLEEPING RMS) = 30 PSF

LIVE LOAD (ATTIC) = 20 PSF

LIVE LOAD (DECK) = 40 PSF


ZONING DATA

SECTION: BLOCK: 95 LOT(S): 6

ZONE: RA	REQUIRED	PROVIDED
LOT AREA	5000 SF.	4,500 SF.
LOT WIDTH	50 FT.	36 FT. (EXIST)
LOT DEPTH	N/A	125 FT.
FRONT YARD	20 FT.	±11 FT. (EXIST)
REAR YARD	15 FT.	±67 FT. (EXIST)
SIDE YARD (MIN/TOTAL)	6/16 FT	±0/13.5 FT. (EXIST)
BUILDING HEIGHT	30 FT	±27'-7" FT
BUILDING COVERAGE	30% (40% W/ AS.)	±27%
IMPERVIOUS COVERAGE	60%	±80% (EXIST)
ACCESSORY STRUCTURE	REQUIRED	PROVIDED
REAR YARD	3 FT.	15 FT (EXIST)
SIDE YARD (MIN)	3 FT.	1 FT (EXIST)
BUILDING HEIGHT	16 FT.	13 FT


ADDITION & ALTERATION TO:
128 FIRST STREET
KEYPORT, NJ 07735

KINETIC
ARCHITECTS

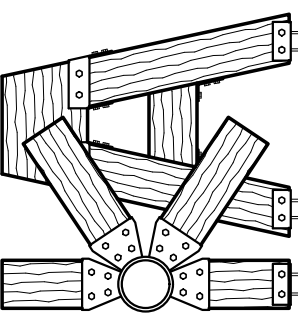

2244 WINFIELD ST.
RAHWAY, NJ
P (732) 910-6178

GJUNKROFT@
KINETICARCHITECTS.COM

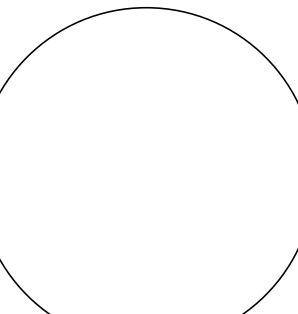

Gary Junkroft RA
NJ LIC. # 17679

THE DRAWINGS, SPECIFICATIONS AND OTHER DOCUMENTS PREPARED BY THE ARCHITECT (CONSULTANTS) FOR THIS PROJECT ARE TO BE USED ONLY FOR THE PROJECT AND NOT FOR ANY OTHER PROJECT. THE ARCHITECT (CONSULTANTS) SHALL NOT BE RESPONSIBLE FOR ANY CHANGES OR MODIFICATIONS TO THE DRAWINGS, SPECIFICATIONS AND OTHER DOCUMENTS THAT ARE MADE BY ANY OTHER PARTY. THE ARCHITECT (CONSULTANTS) SHALL NOT BE RESPONSIBLE FOR ANY CHANGES OR MODIFICATIONS TO THE DRAWINGS, SPECIFICATIONS AND OTHER DOCUMENTS THAT ARE MADE BY ANY OTHER PARTY. THE ARCHITECT (CONSULTANTS) SHALL NOT BE RESPONSIBLE FOR ANY CHANGES OR MODIFICATIONS TO THE DRAWINGS, SPECIFICATIONS AND OTHER DOCUMENTS THAT ARE MADE BY ANY OTHER PARTY.

COVER SHEET
INDEX
LOC. MAP
GEN. NOTES

REVISIONS:


DATE: 01/08/23

DRAWN BY: GAJ


CHECKED BY: GAJ

JOB # 21-256


A-1
1 OF 5

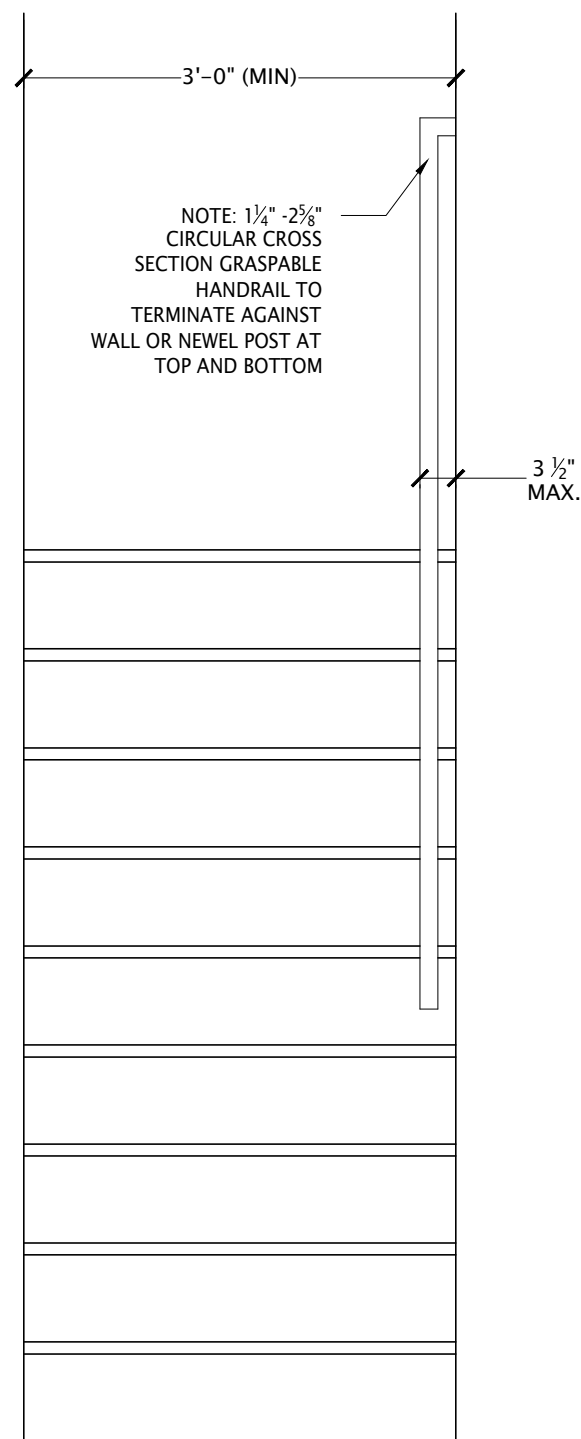


SCALE = $\frac{3}{4}"=1'-0"$

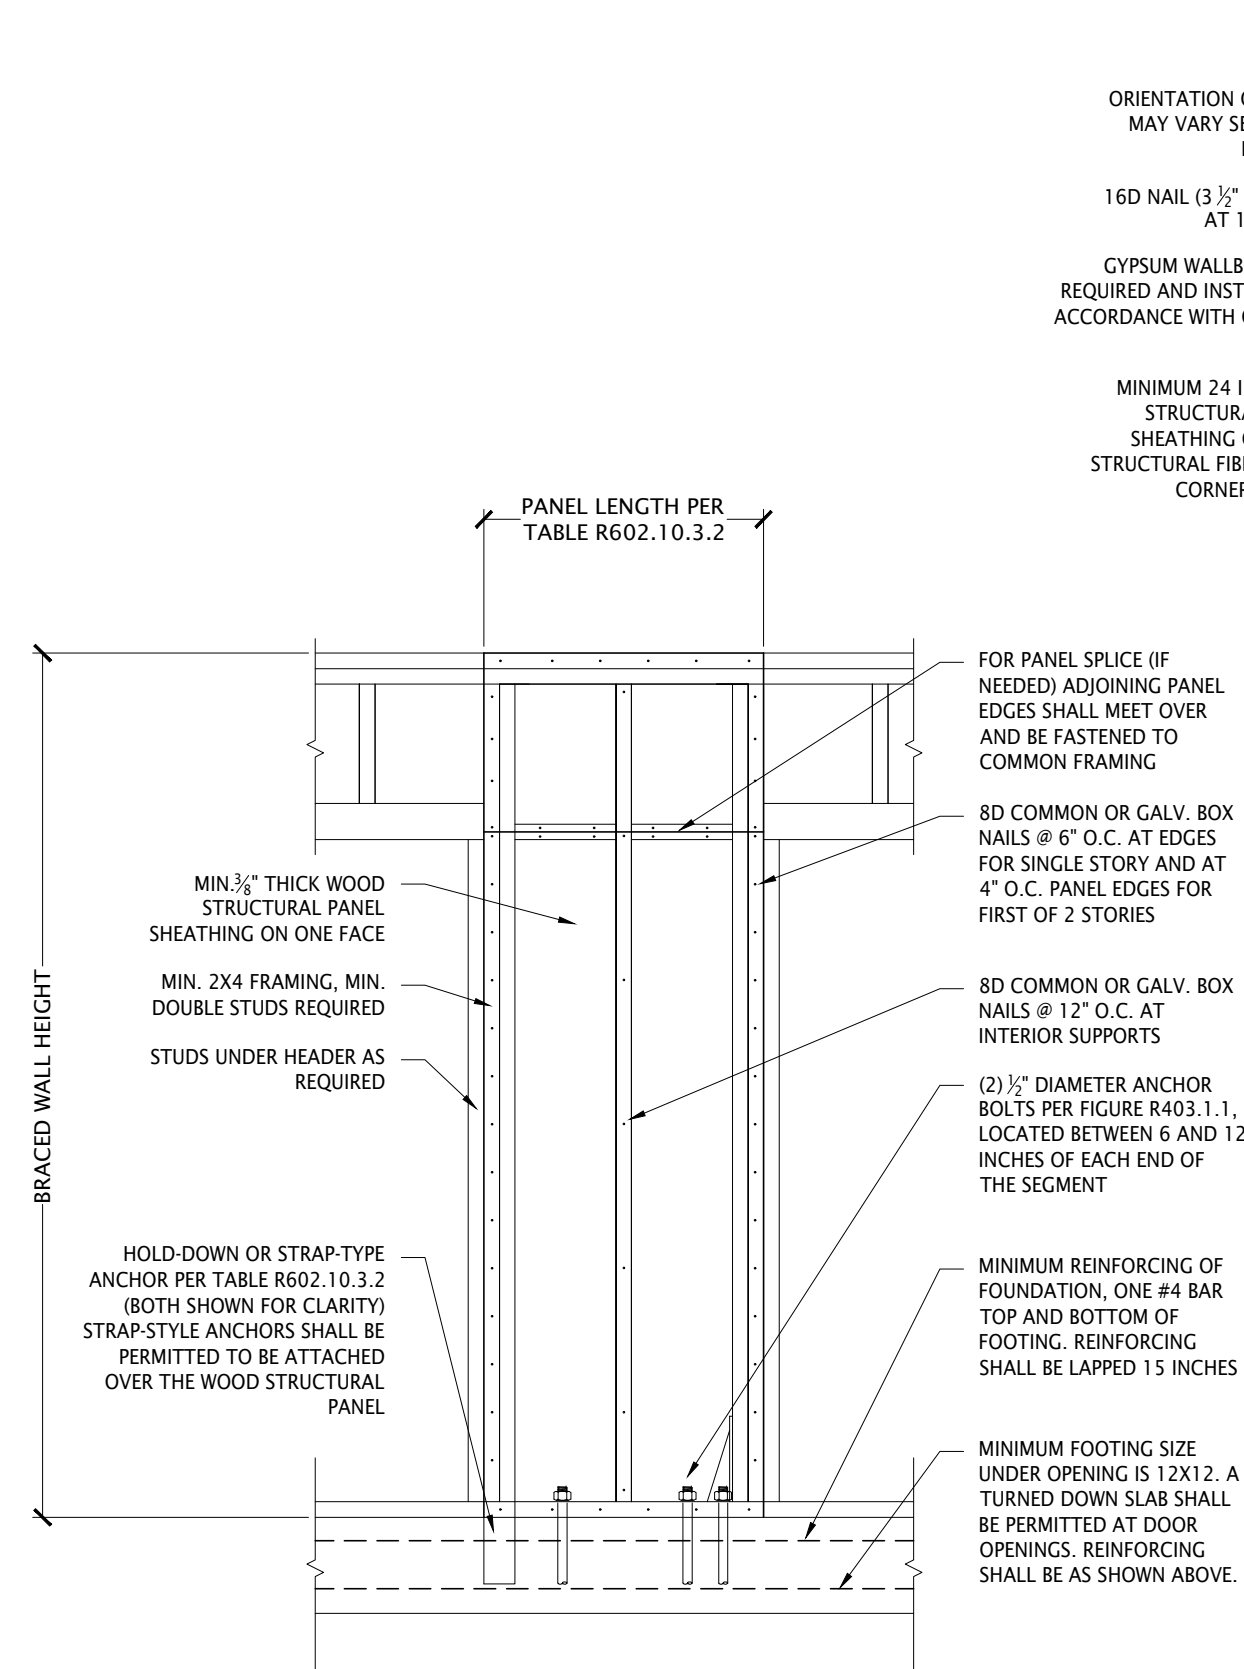


SCALE = $\frac{3}{4}" = 1'-0"$

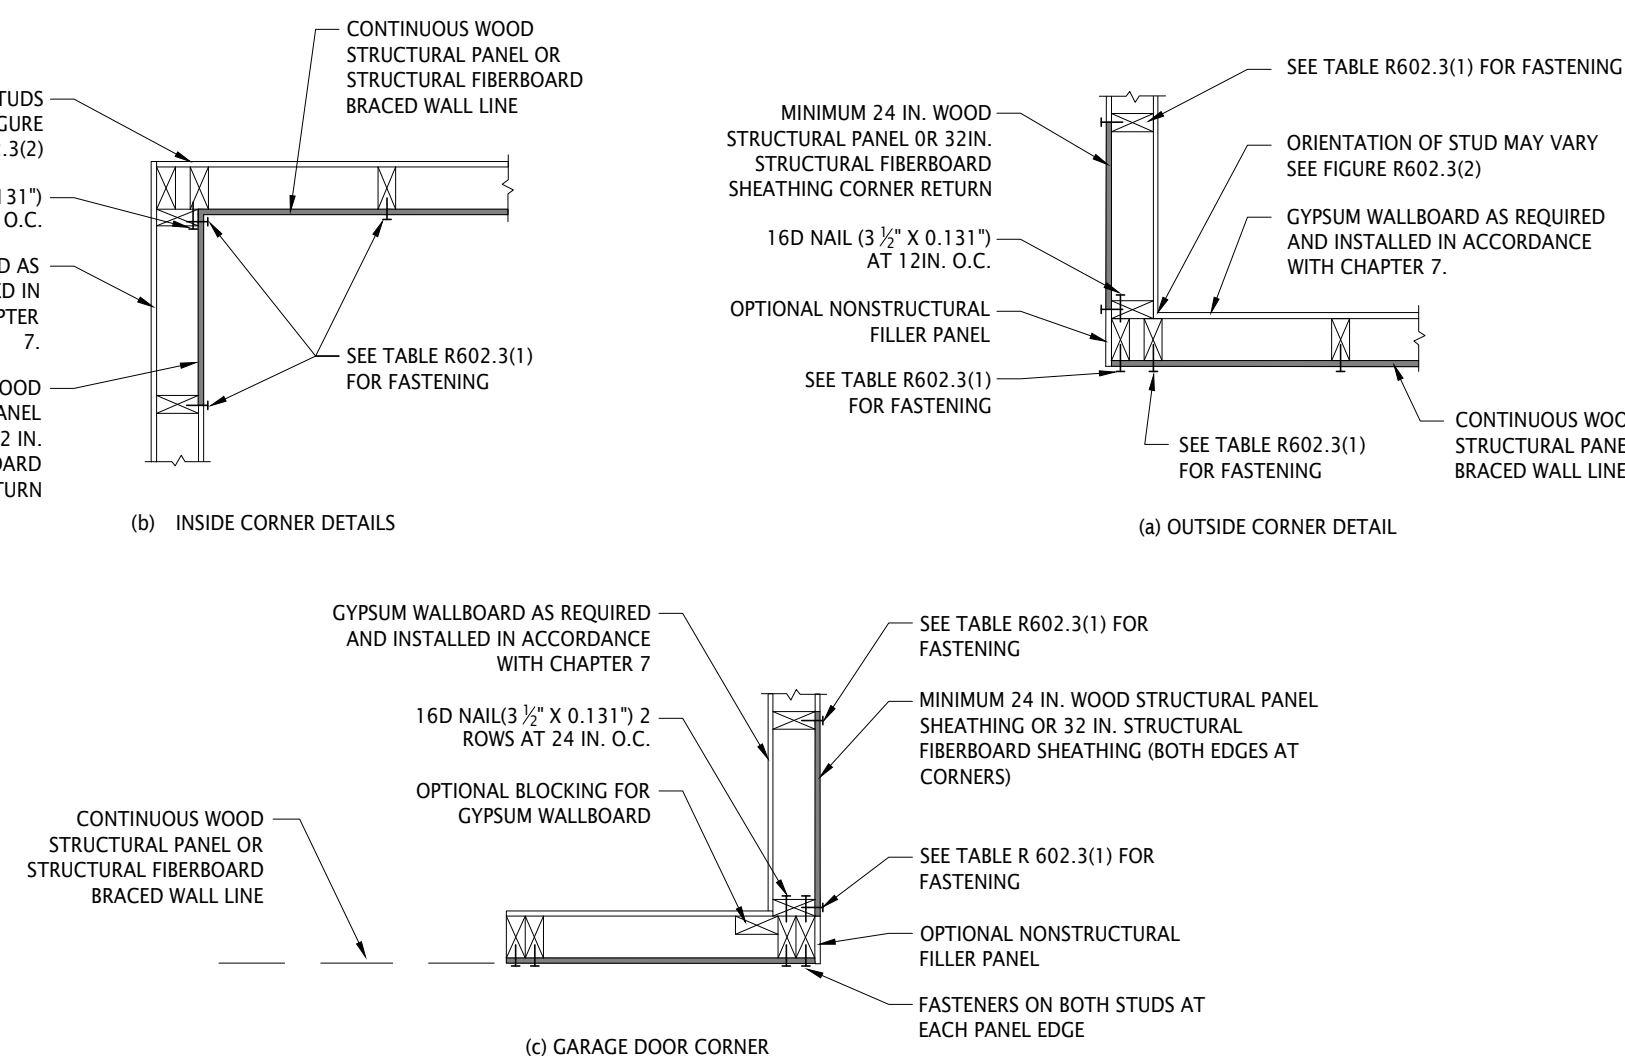

NAILING REQUIREMENTS: 6d COMMON (2.0"x0.113), PENETRATION OF 1.5", PANEL RATING OF 24/0, MIN. PANEL THICKNESS OF 3/8", MAX. WALL STUD SPACING OF 16" O.C., PANEL NAIL SPACING OF 6" O.C. AT EDGES, AND 12" O.C. IN THE FIELD.

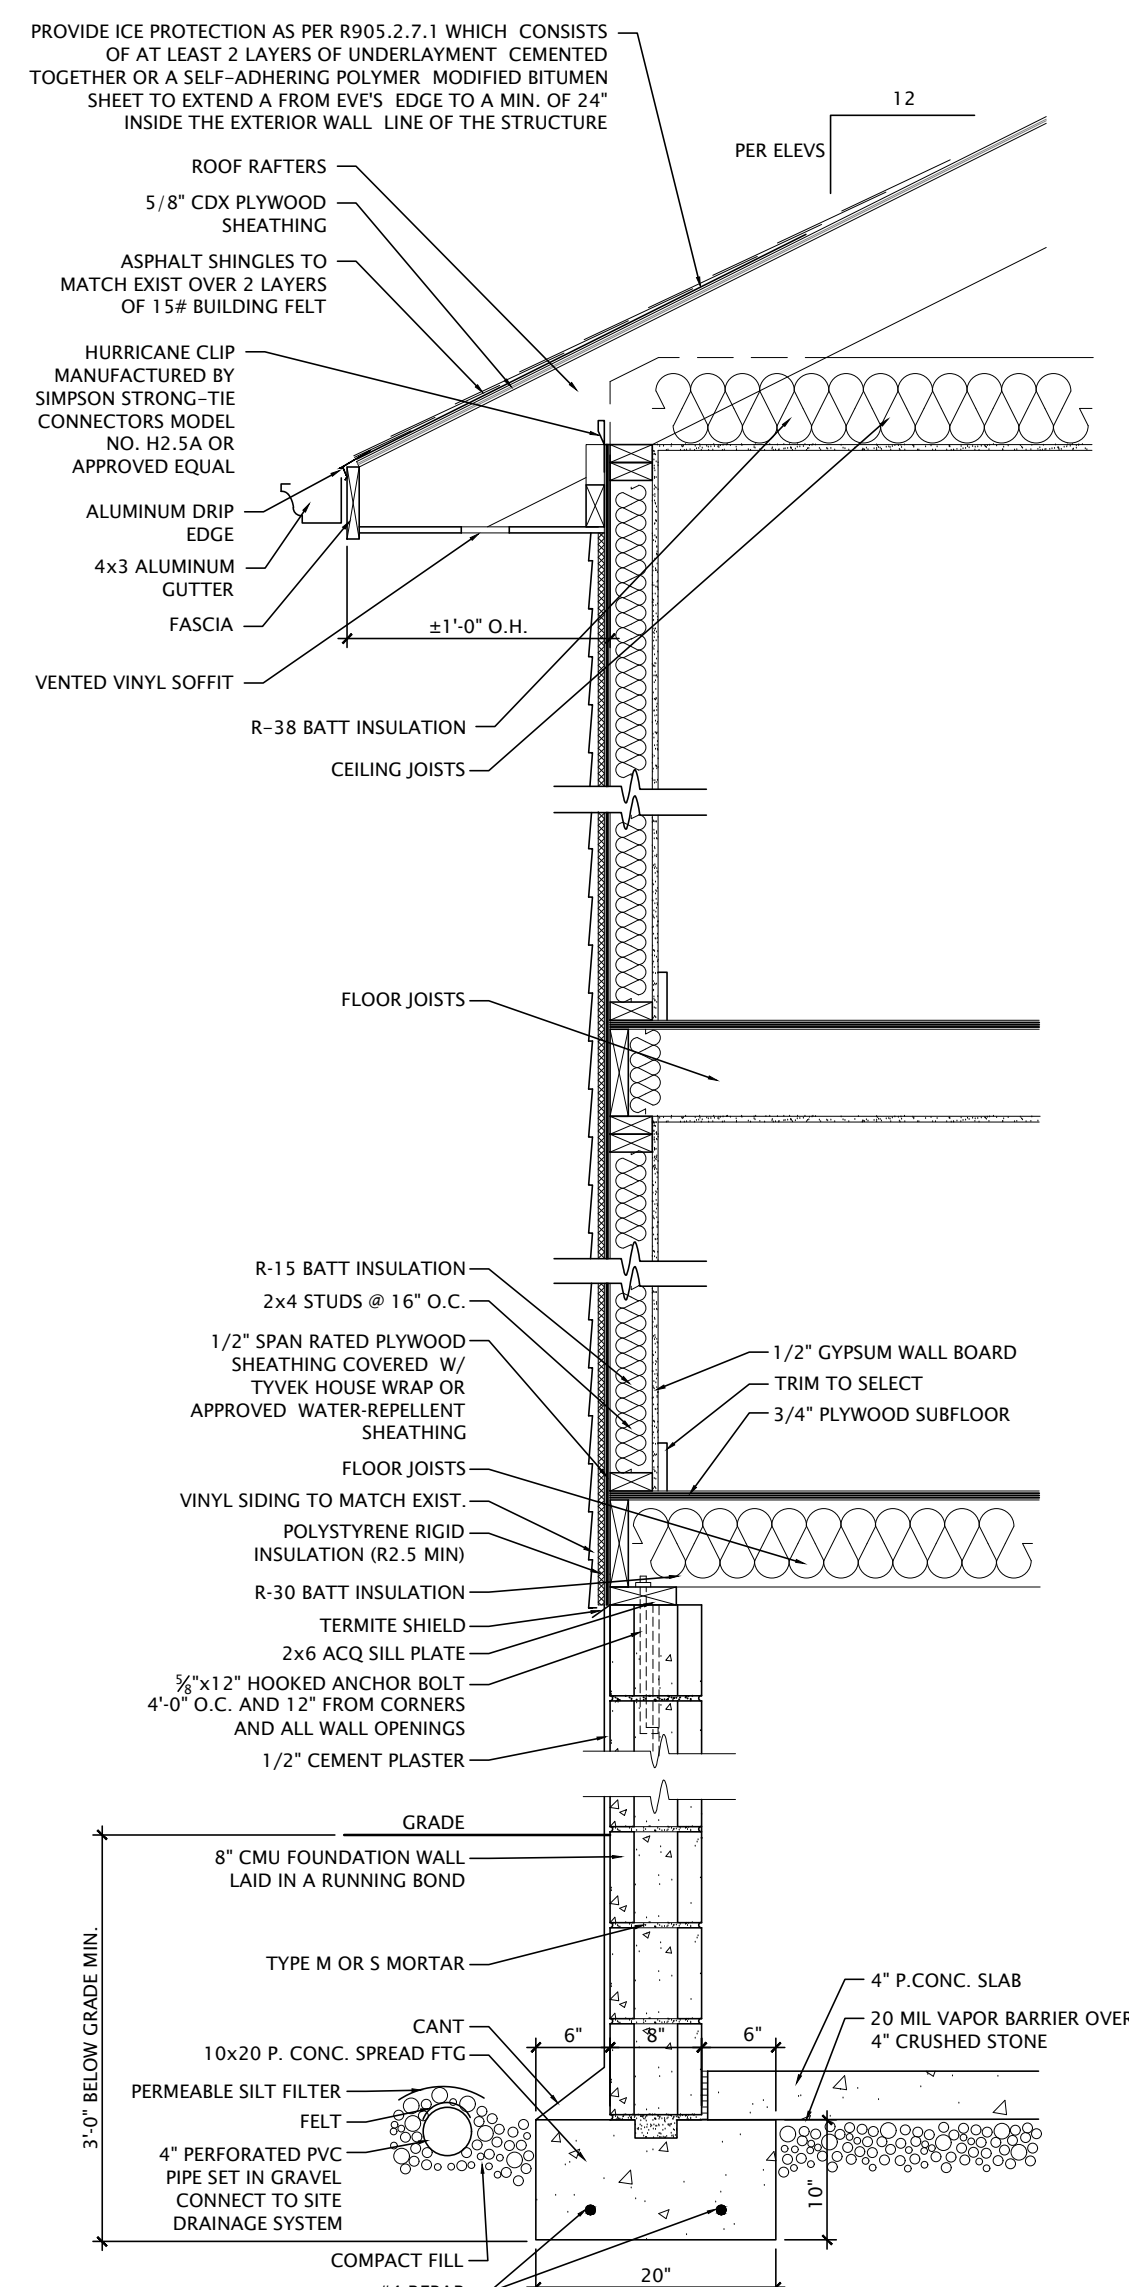

SCALE = $\frac{3}{4}" = 1'-0"$

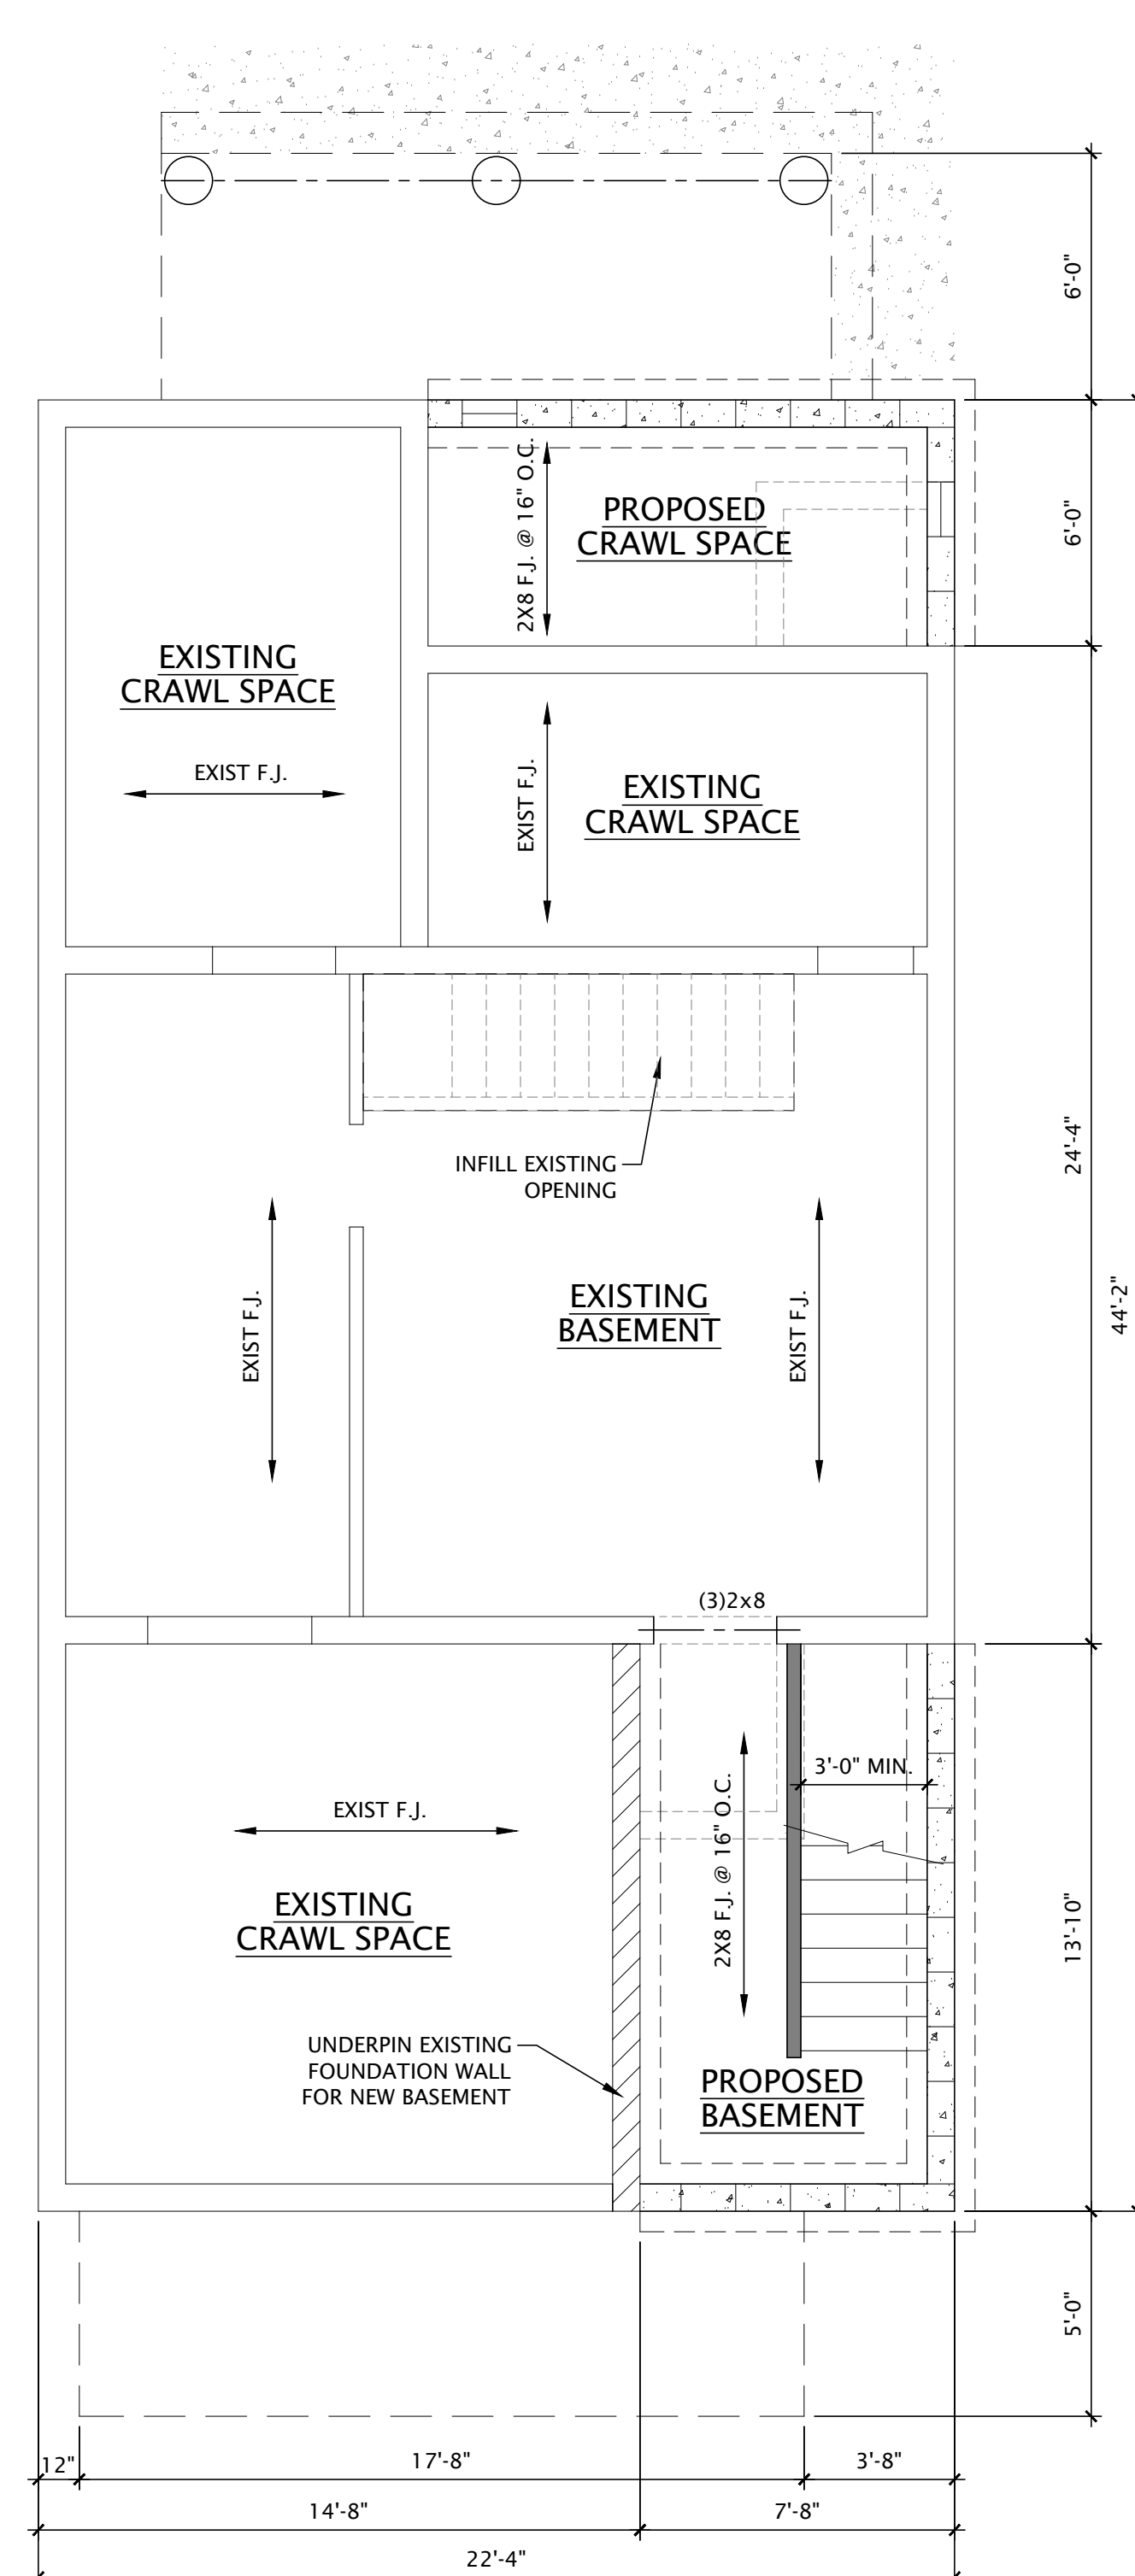


SCALE = $\frac{1}{4}" = 1'-0"$




ADDITIONAL NAILING OR BOLTING MAY BE REQUIRED WITH SIDE-LOADED MULTIPLE MEMBER BEAMS. REFER TO CURRENT PRODUCT LITERATURE.

NOTE:
CONTRACTOR TO COORDINATE FINAL
WINDOW & DOOR SIZE AND STYLE
SELECTION WITH OWNER AND FIELD
VERIFY OPENING SIZES PRIOR TO
ORDERING

1. ALL WORK TO BE DONE IN ACCORDANCE WITH NEW JERSEY UNIFORM CONSTRUCTION CODE.
2. CONTRACTOR TO INSPECT AND VERIFY ALL SITE CONDITIONS.
3. ALL FOOTINGS TO BEAR ON VIRGIN SOIL.
4. SOIL BEARING CAPACITY ASSUMED TO BE TWO (2) TONS. IF SOIL ENCOUNTERED IS LESS NOTIFY ARCHITECT.
5. ALL BELOW GRADE BLOCK IS TO BE HOLLOW CORE LOAD BEARING TYPE FOR BELOW GRADE CONSTRUCTION.
6. STEPPED FOOTINGS WHERE NECESSARY SHALL BE STEPPED AT A RATIO OF ONE VERTICAL BLOCK FOR EVERY TWO HORIZONTAL BLOCKS (MINIMUM).
7. CONCRETE SHALL HAVE A MINIMUM 28-DAY STRENGTH OF 3000 PSI UNLESS OTHERWISE NOTED.
8. DUR-O-WALL TRUSS-TYPE REINFORCING TO BE USED EVERY OTHER BLOCK COURSE (BELOW GRADE).
9. ALL FRAMING LUMBER TO BE NO.2 DOUGLAS FIR OR SOUTHERN PINE MINIMUM Fb = 1250 PSI.
10. PROVIDE DOUBLE JOISTS UNDER ALL PARTITIONS PARALLEL TO JOISTS. ALL FLOOR AND ROOF OPENINGS TO BE BOXED WITH DOUBLE JOISTS HEADERS.
11. ALL NAILING TO BE DONE IN ACCORDANCE WITH IRC TABLE R602.3(1).
12. ELECTRICAL LAYOUT IS SCHEMATIC AND SHALL BE INSTALLED AS PER N.J.A.C. 523-31.6.
13. PLUMBING TO BE INSTALLED AS PER N.J.A.C. 523-31.5.
14. THESE PLANS COMPLY WITH NEW JERSEY ENERGY SUB-CODE.
15. CONTRACTOR TO VERIFY AND BE RESPONSIBLE FOR ALL DIMENSIONS.
16. PROVIDE STEEL LINTELS OVER ALL BRICK OPENINGS (WHERE REQUIRED) LINTELS TO BE 3 1/2" X 3 1/2" X 1/4" UNLESS OTHERWISE NOTED.
17. ALL WOOD TO BE USED FOR EXTERIOR DECKING TO BE PRESSURE -TREATED
18. CONTRACTOR IS TO BE RESPONSIBLE FOR GETTING ALL REQUIRED BUILDING PERMITS, FEES AND INSPECTIONS
19. SMOKE DETECTORS TO BE HARDWIRED SO THAT IF ONE DETECTOR SIGNALS ALL WILL SIGNAL. ALL DETECTORS TO HAVE BATTERY BACK - UP SYSTEM.
20. IF FUEL- BURNING APPLIANCES ARE TO BE USED PROVIDE EITHER HARDWIRED OR PLUG-IN TYPE CARBON MONOXIDE DETECTOR IN IMMEDIATE VICINITY OF THE SLEEPING ROOMS.
21. ALL HEADERS ABOVE OPENING ARE TO BE (2) 2" X 10" UNLESS OTHERWISE NOTED.
22. PROVIDE CEMENT FIBER- CEMENT OR GLASS MAT GYPSUM BACKERS IN TUB/SHOWER AREAS.
23. CONTRACTOR TO PROVIDE WALLS AND CEILINGS WITH GYP BOARD AND 3 COATS SANDED JOINT COMPOUND.
24. ALL METAL HANGERS AND ANCHOR BOLTS ATTACHED TO PRESSURE-TREATED LUMBER TO BE HOT-DIPPED GALVANIZED (G-185 MINIMUM).
25. FIREPLACES TO DRAW COMBUSTION AIR FROM EXTERIOR.
26. ALL EXPOSED ROOFS TO BE INSULATED WITH R-15 INSULATION.
27. ALL EXPOSED WALL/ CEILING AREA AT THE ATTIC TO INSULATED WITH R-38, OR THE EQUIVALENT THAT THE JOIST/RAFTER WILL ALLOW. PROVIDE Baffles ON SLOPED CEILINGS TO MAINTAIN AIR CIRCULATION AGAINST THE ROOF.


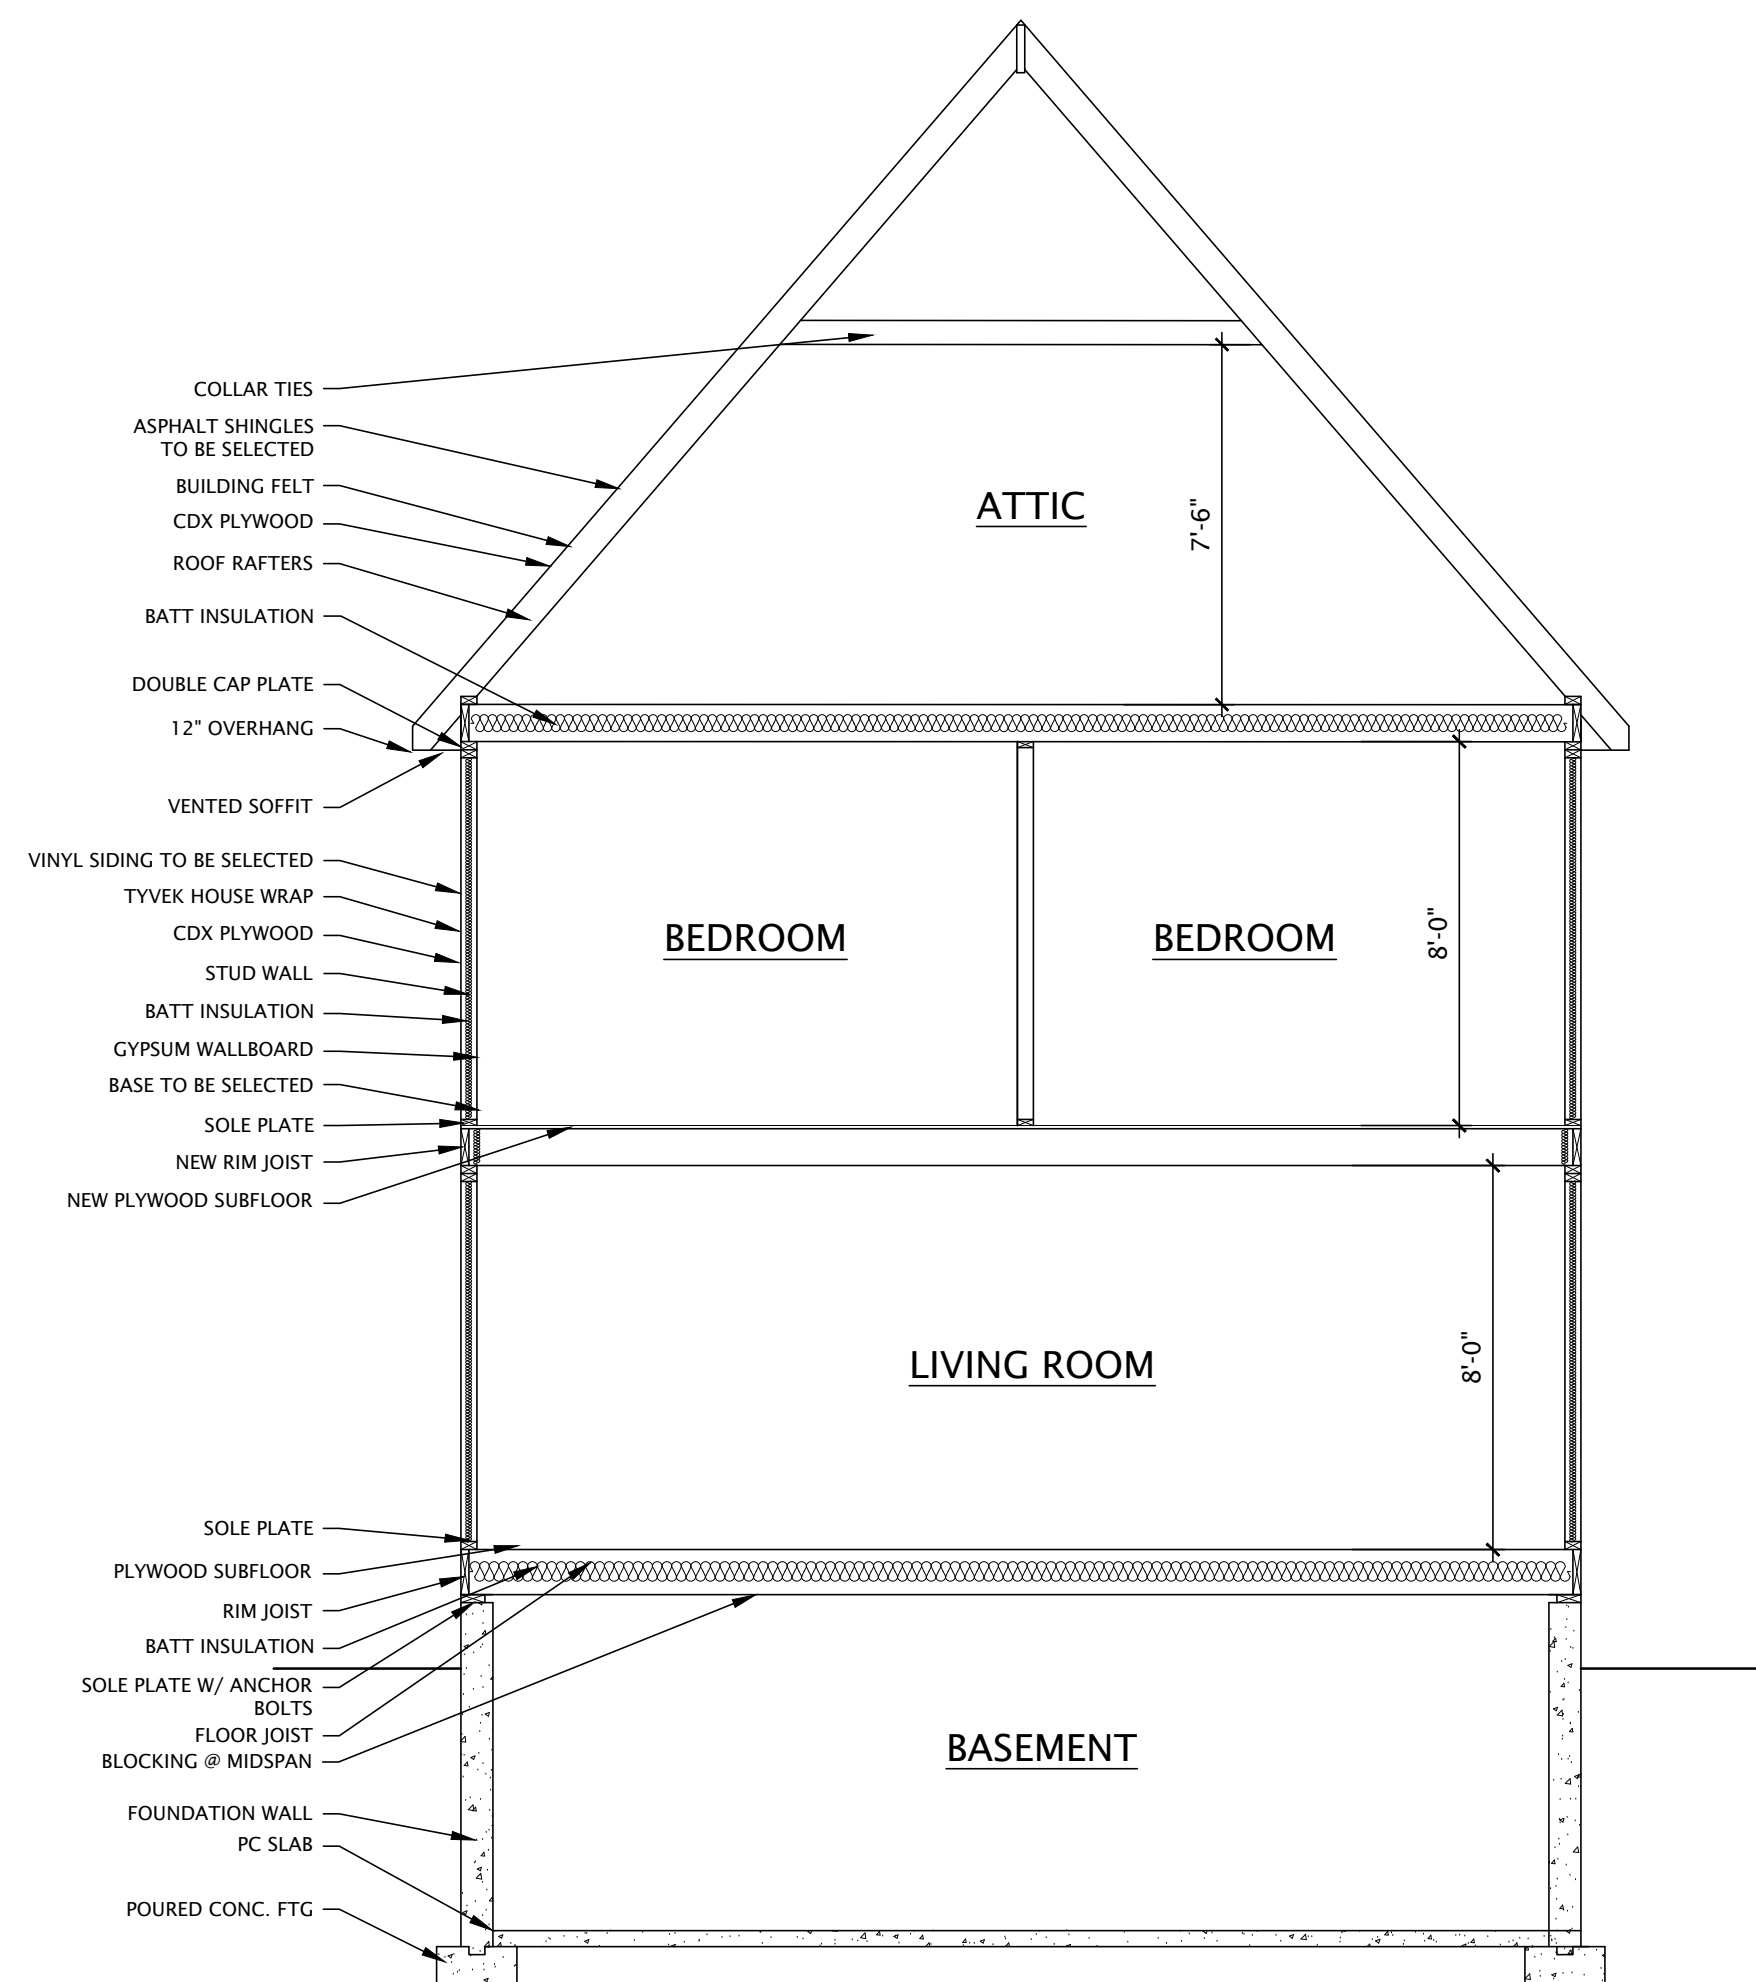


SCALE = $\frac{3}{4}" = 1'-0"$

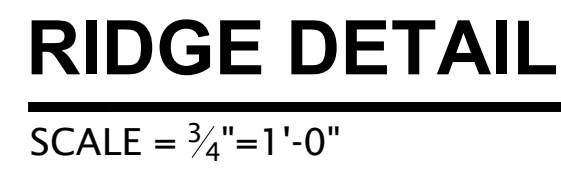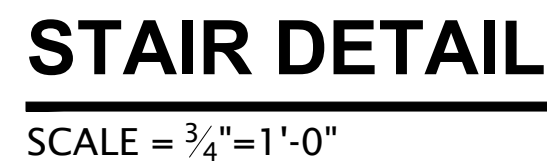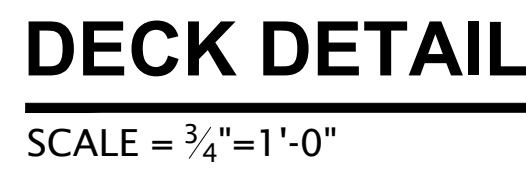


DECK DETAIL

SCALE = $\frac{3}{4}" = 1'-0"$

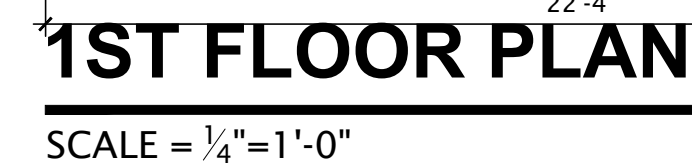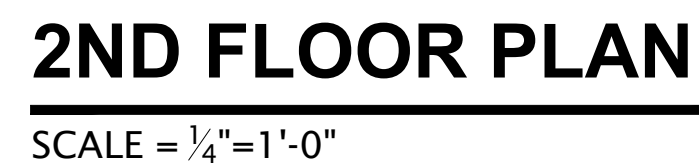



- | | |
|---|--------------------|
|  | EXISTING TO REMOVE |
|  | EXISTING TO REMAIN |
|  | NEW STUD WALL |
|  | BEARING WALL |
|  | POURED CONCRETE |
|  | CONCRETE BLOCK |
|  | INSULATION |

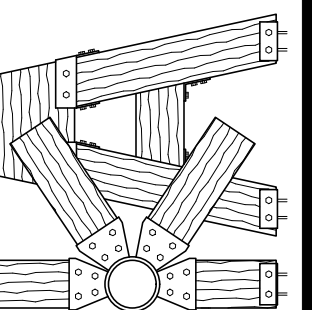KINETIC
ARCHITECTS

THE DRAWINGS, SPECIFICATIONS AND OTHER DOCUMENTS ARE THE INSTRUMENTS OF THE ARCHITECT'S CONSULTANTS AND, THEREFORE, THE SERVICES OF THE ARCHITECT'S CONSULTANTS AND, UNLESS OTHERWISE PROVIDED, THE ARCHITECT'S CONSULTANT SHALL BE DEEMED THE AUTHOR OF THESE DOCUMENTS AND SHALL RETAIN ALL COMMON LAW, STATUTORY AND OTHER RESERVED RIGHTS IN THE DOCUMENTS. THE ARCHITECT'S CONSULTANTS SHALL BE OBLIGATED TO RETAIN COPIES OF THE ARCHITECT'S CONSULTANTS' DRAWINGS, SPECIFICATIONS AND OTHER DOCUMENTS FOR THE PROJECT. THE ARCHITECT'S CONSULTANTS' DRAWINGS SHALL NOT BE USED BY THE OWNER OR OTHERS ON OTHER PROJECTS, NOR FOR ADDITIONS TO THIS PROJECT OR FOR COMPLETION OF THIS PROJECT BY OTHERS.

A-3

3 OF **5**

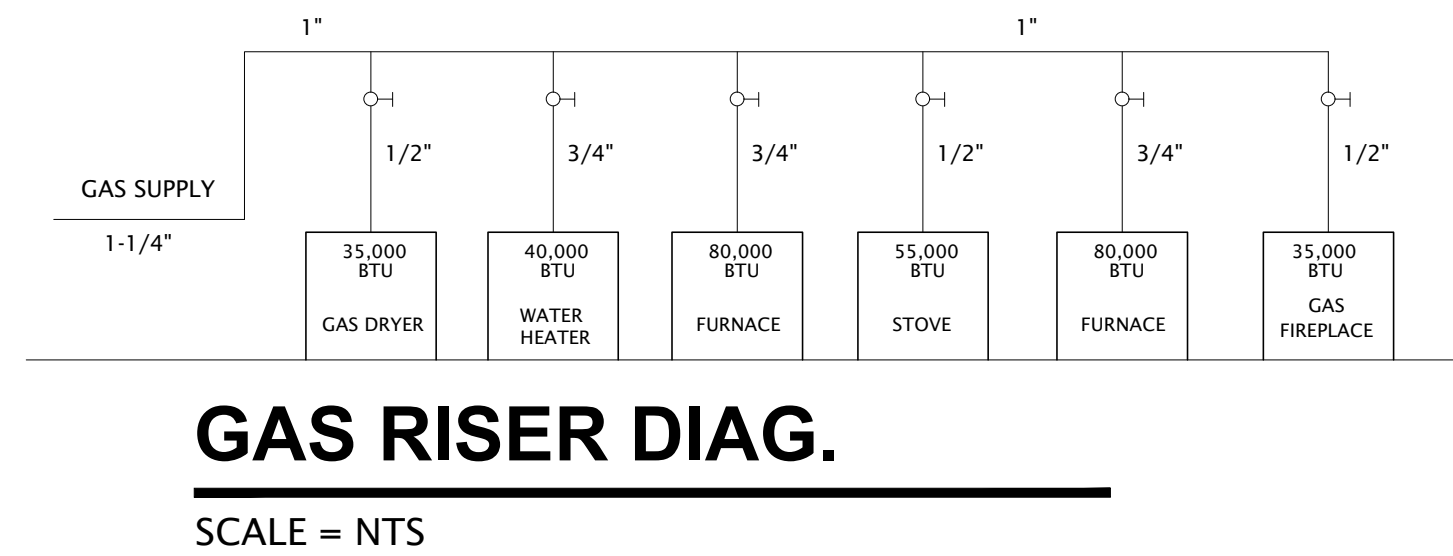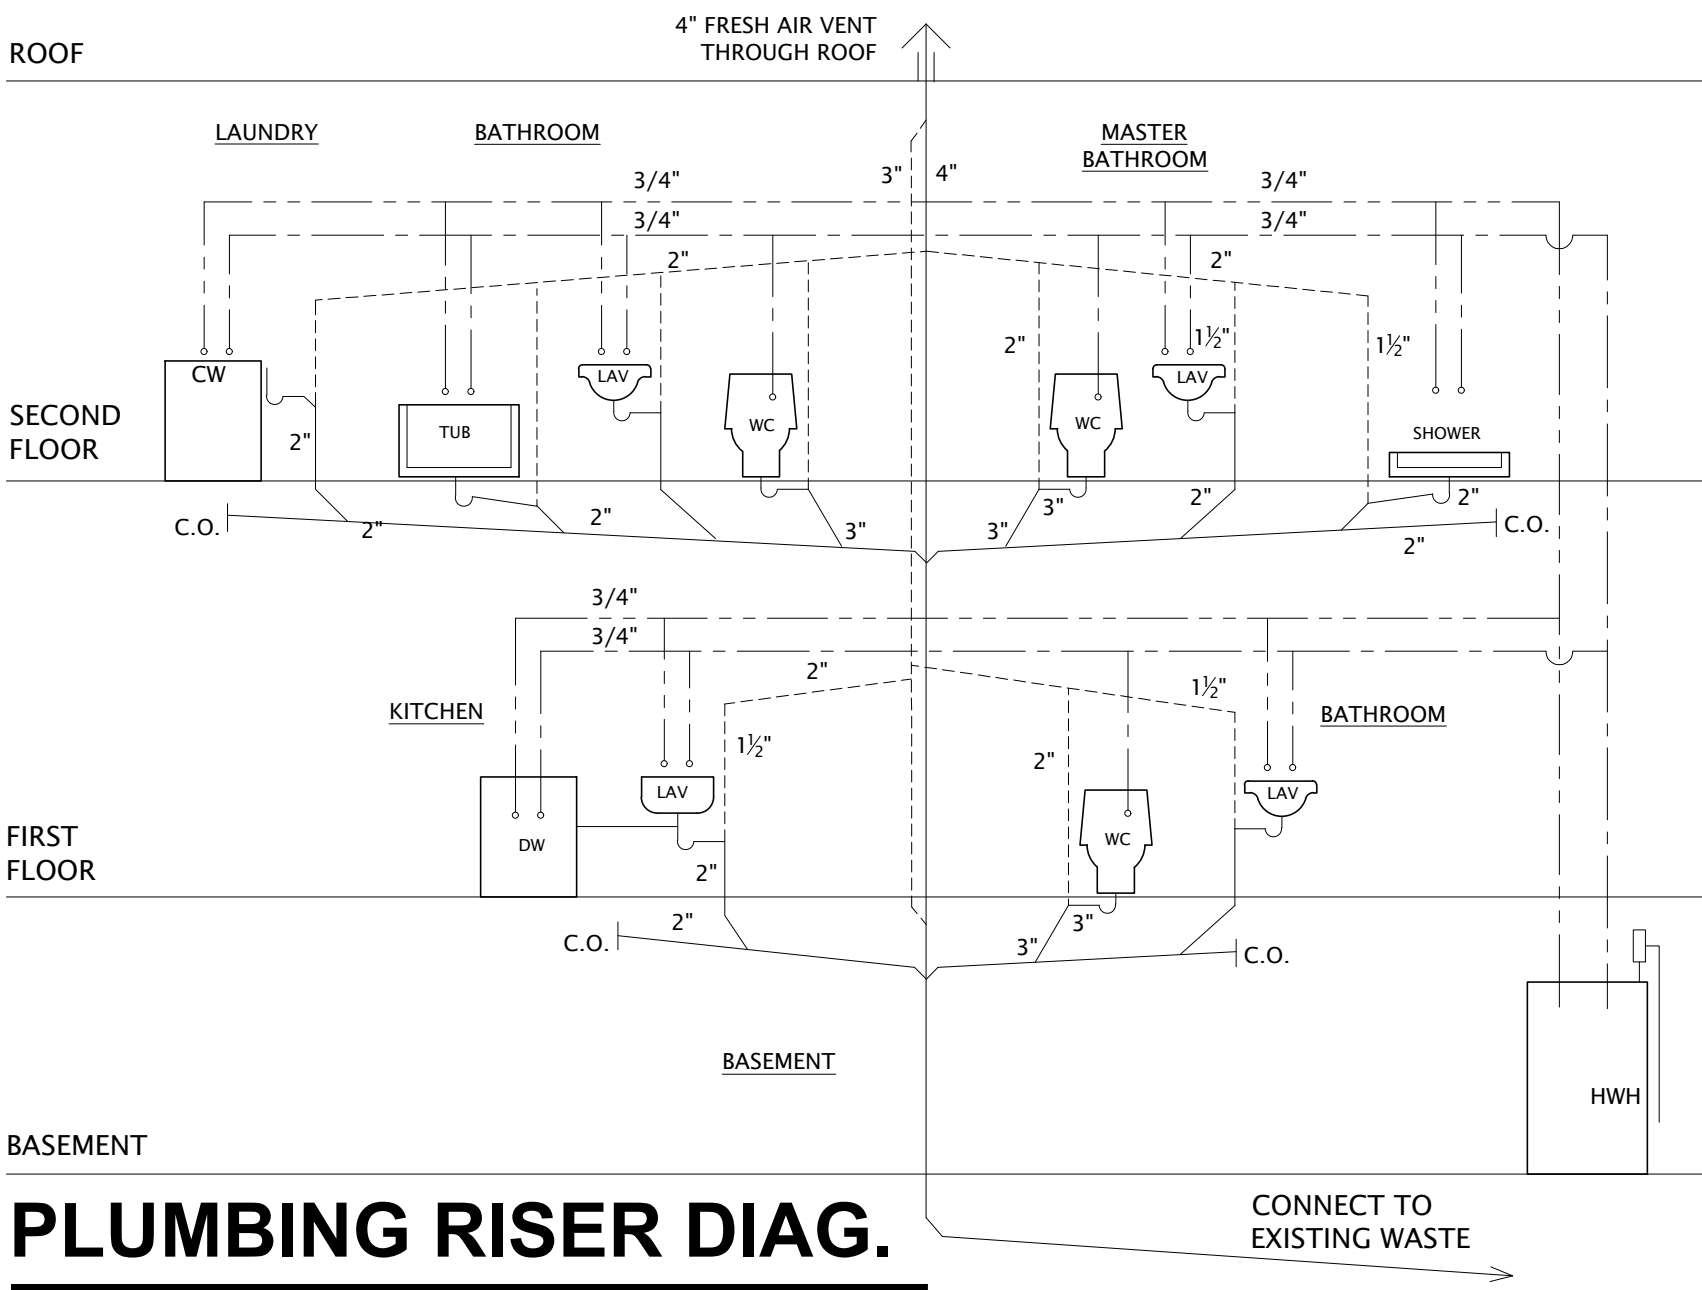

LIGHTING LEGEND

LIGHTING INDEX:			
	4" RECESSED FIXTURE (75W MAX)		SINGLE POLE SWITCH
	6" RECESSED FIXTURE (100W MAX)		3 WAY SWITCH
	2" RECESSED FIXTURE (20W MAX)		4 WAY SWITCH
	4" WALL WASHER (EYE BALL) (75W MAX)		REMOTE CONTROL SWITCH
	6" WALL WASHER (EYE BALL) (100W MAX)		TIMER SWITCH
	PULL CHAIN		DIMMER SWITCH
	LANDSCAPE FIXTURE (FIXTURE SELECTED BY OWNER)		HINGE LIGHT SWITCH
	RECESSED CABINET LIGHT (20W MAX)		JUNCTION BOX
	RECESSED FIXTURE - WET LOCATIONS (50W MAX)		RECESSED FAN
	WALL MOUNT UPLIGHT (100W MAX)		FLOOD LIGHT (100W MAX)
	WALL MOUNT LIGHT (100W MAX)		STANDARD CEILING LIGHT (100W MAX)
	PENDANT LIGHT (200W MAX)		HEAT/FAN/LIGHT COMBINATION (100W MAX)
	CHANDELIER (200W MAX)		
	ROPE LIGHTING		UNDER-COUNTER LIGHTS (20W MAX)
	TRACK LIGHTING		LOW LEVEL LIGHTING (20W MAX)
	BATH BAR		
	24" X 24" LED LIGHT FIXTURE		12" X 48" 1 STRIP FLORESCENT LIGHT FIXTURE
	SOLAR TUBE		2 STRIP - 8"-0" FLORESCENT LIGHT FIXTURE
	SKYLIGHT		
	FAN		
	FAN W/ LIGHT		

NOTE:
CONFIRM ALL LIGHT FIXTURE SELECTIONS AND LAYOUT WITH OWNER.

NOTE:
VERIFY ALL CONSTRUCTION DOCUMENTS AND NOTIFY ARCHITECT OF ANY DISCREPANCIES.




NOTE:
ONLY NEW ELECTRIC WORK IS SHOWN. EXISTING TO REMAIN IS NOT INDICATED.

NOTE:
SMOKE DETECTORS ARE TO BE LOCATED NO LESS THEN 3 FEET FROM BATHROOM DOORS AND HVAC SUPPLY AND RETURN DUCTS

NOTE:
ALL HVAC SUPPLY DUCTWORK IN UNCONDITIONED ATTIC SPACES TO BE R-8 MIN., RETURN DUCTS TO BE R-8 MIN..


POWER LEGEND

POWER INDEX:			
	DUPLEX OUTLET		CENTRAL VACUUM DRAW
	220 VOLTAGE RECEPTACLE		INFRARED SENSOR
	SPLIT WIRED RECEPTACLE		CAT 5 CABLE HOOK UP
	4-PLEX OUTLET		THERMOSTAT
	FLOOR MOUNTED OUTLET		PANEL BOARD
	UNDER-COUNTER (UNLESS NOTED OTHERWISE)		SPECIAL DUTY OUTLET
	GROUND FAULT CIRCUIT INTERRUPTER		JUNCTION BOX
	WATER PROOF GROUND FAULT RECEPTACLE		UTILITY METER
	PHOTOCELL LIGHT		LOW VOLTAGE WIRING
	TELEPHONE JACK		MAIN DISCONNECT SWITCH
	AUDIO		TRANSFORMER
	CARBON MONOXIDE DETECTOR - HARD WIRED		AUTOMATIC DOOR OPENER
	SMOKE DETECTOR - HARD WIRED INT. CON.		DOOR BELL
	DOOR BELL CHIMES		PUSH BUTTON
	VACUUM PORTS (CENTRAL VACUUM)		1" CONDUIT TO MEDIA CLOSET. SEPARATE DISTINCT CONDUIT AT EACH NOTED AREA.
	TELEVISION COAX RECEPTACLE		

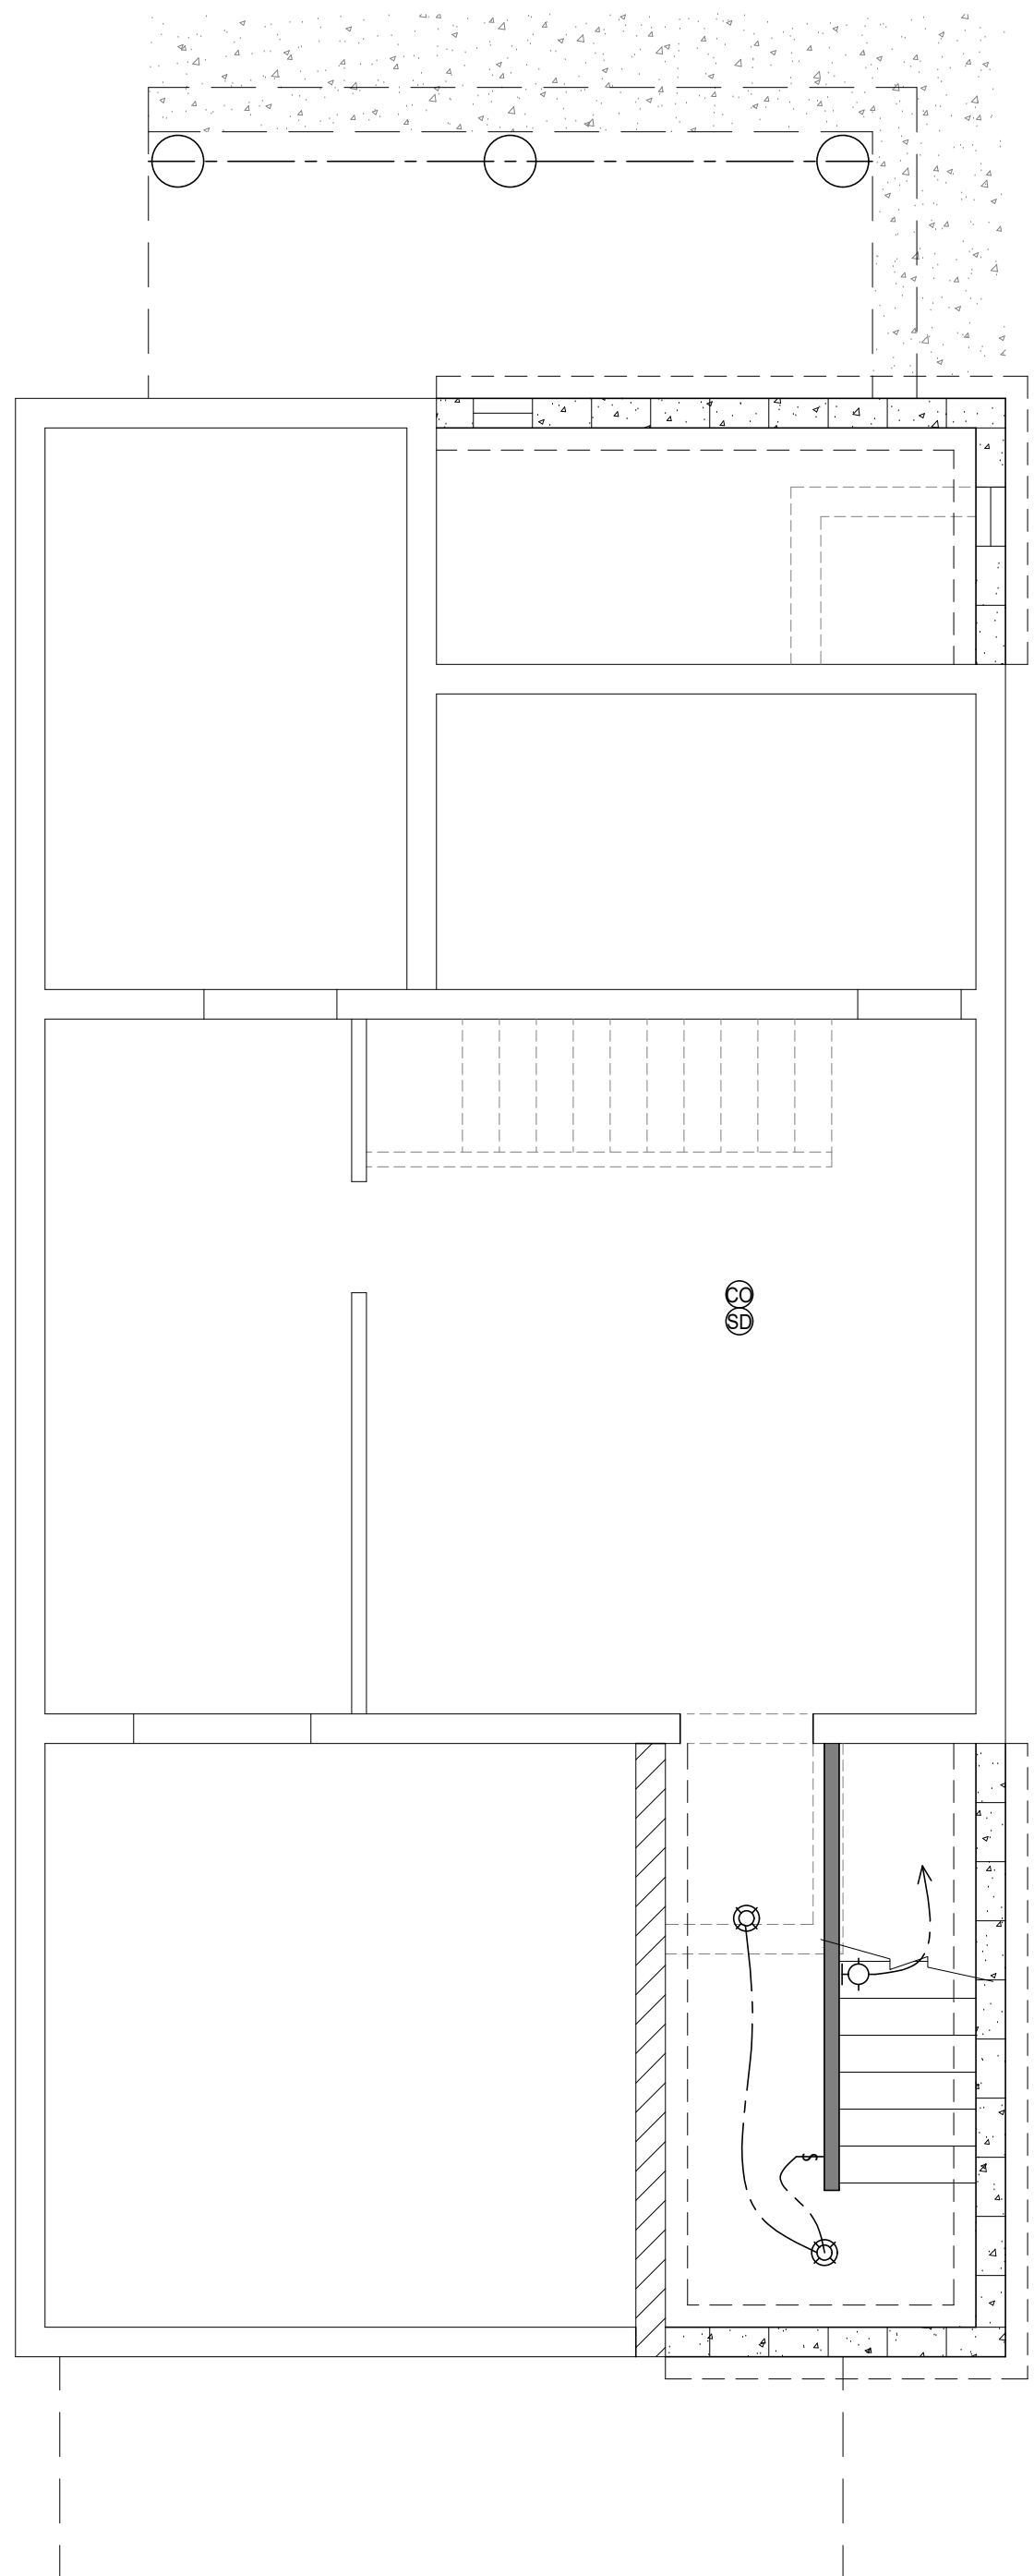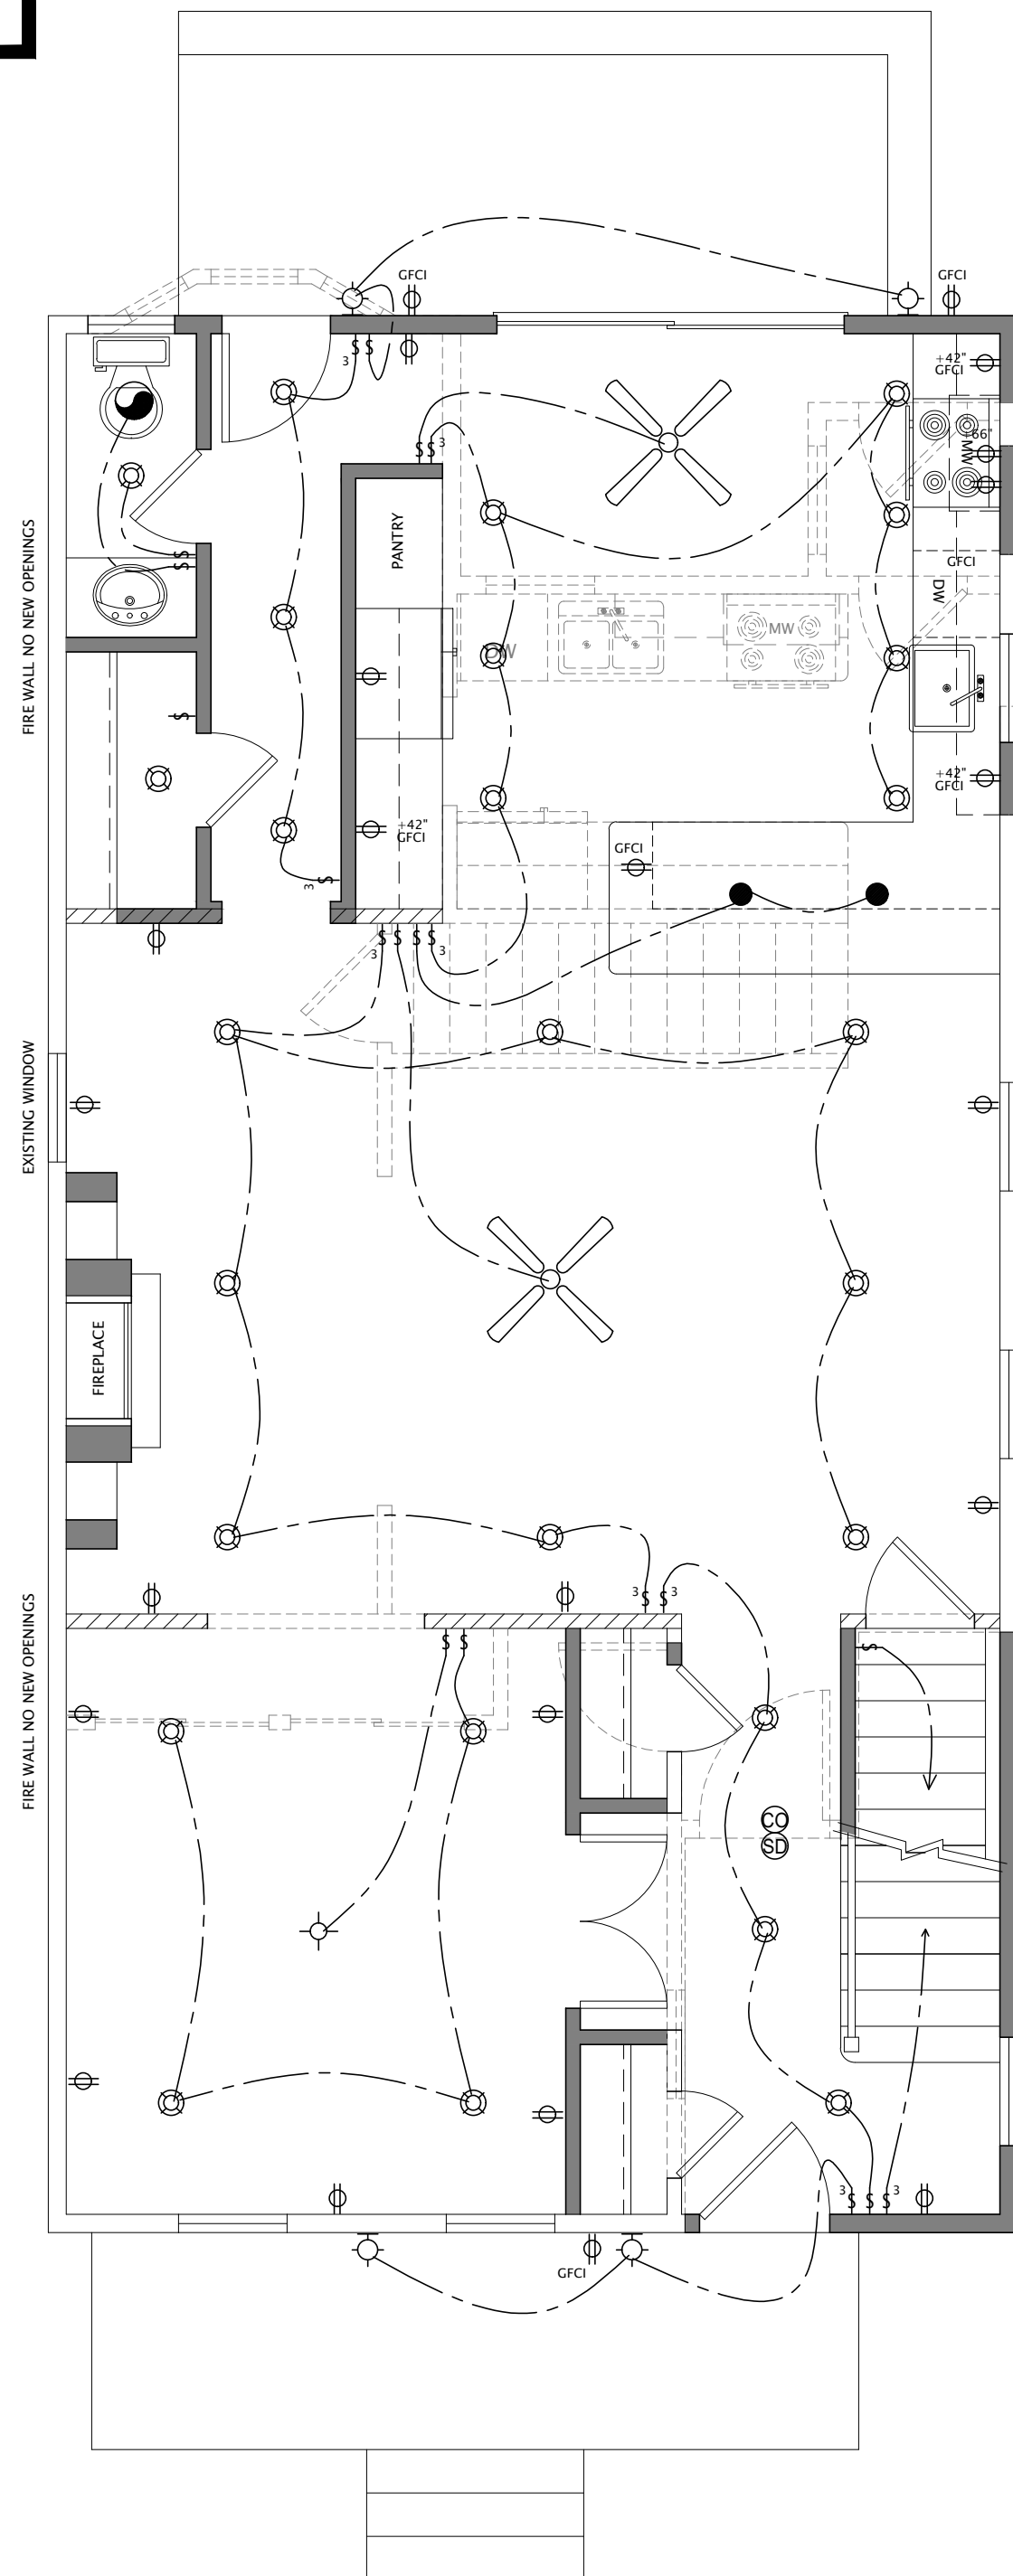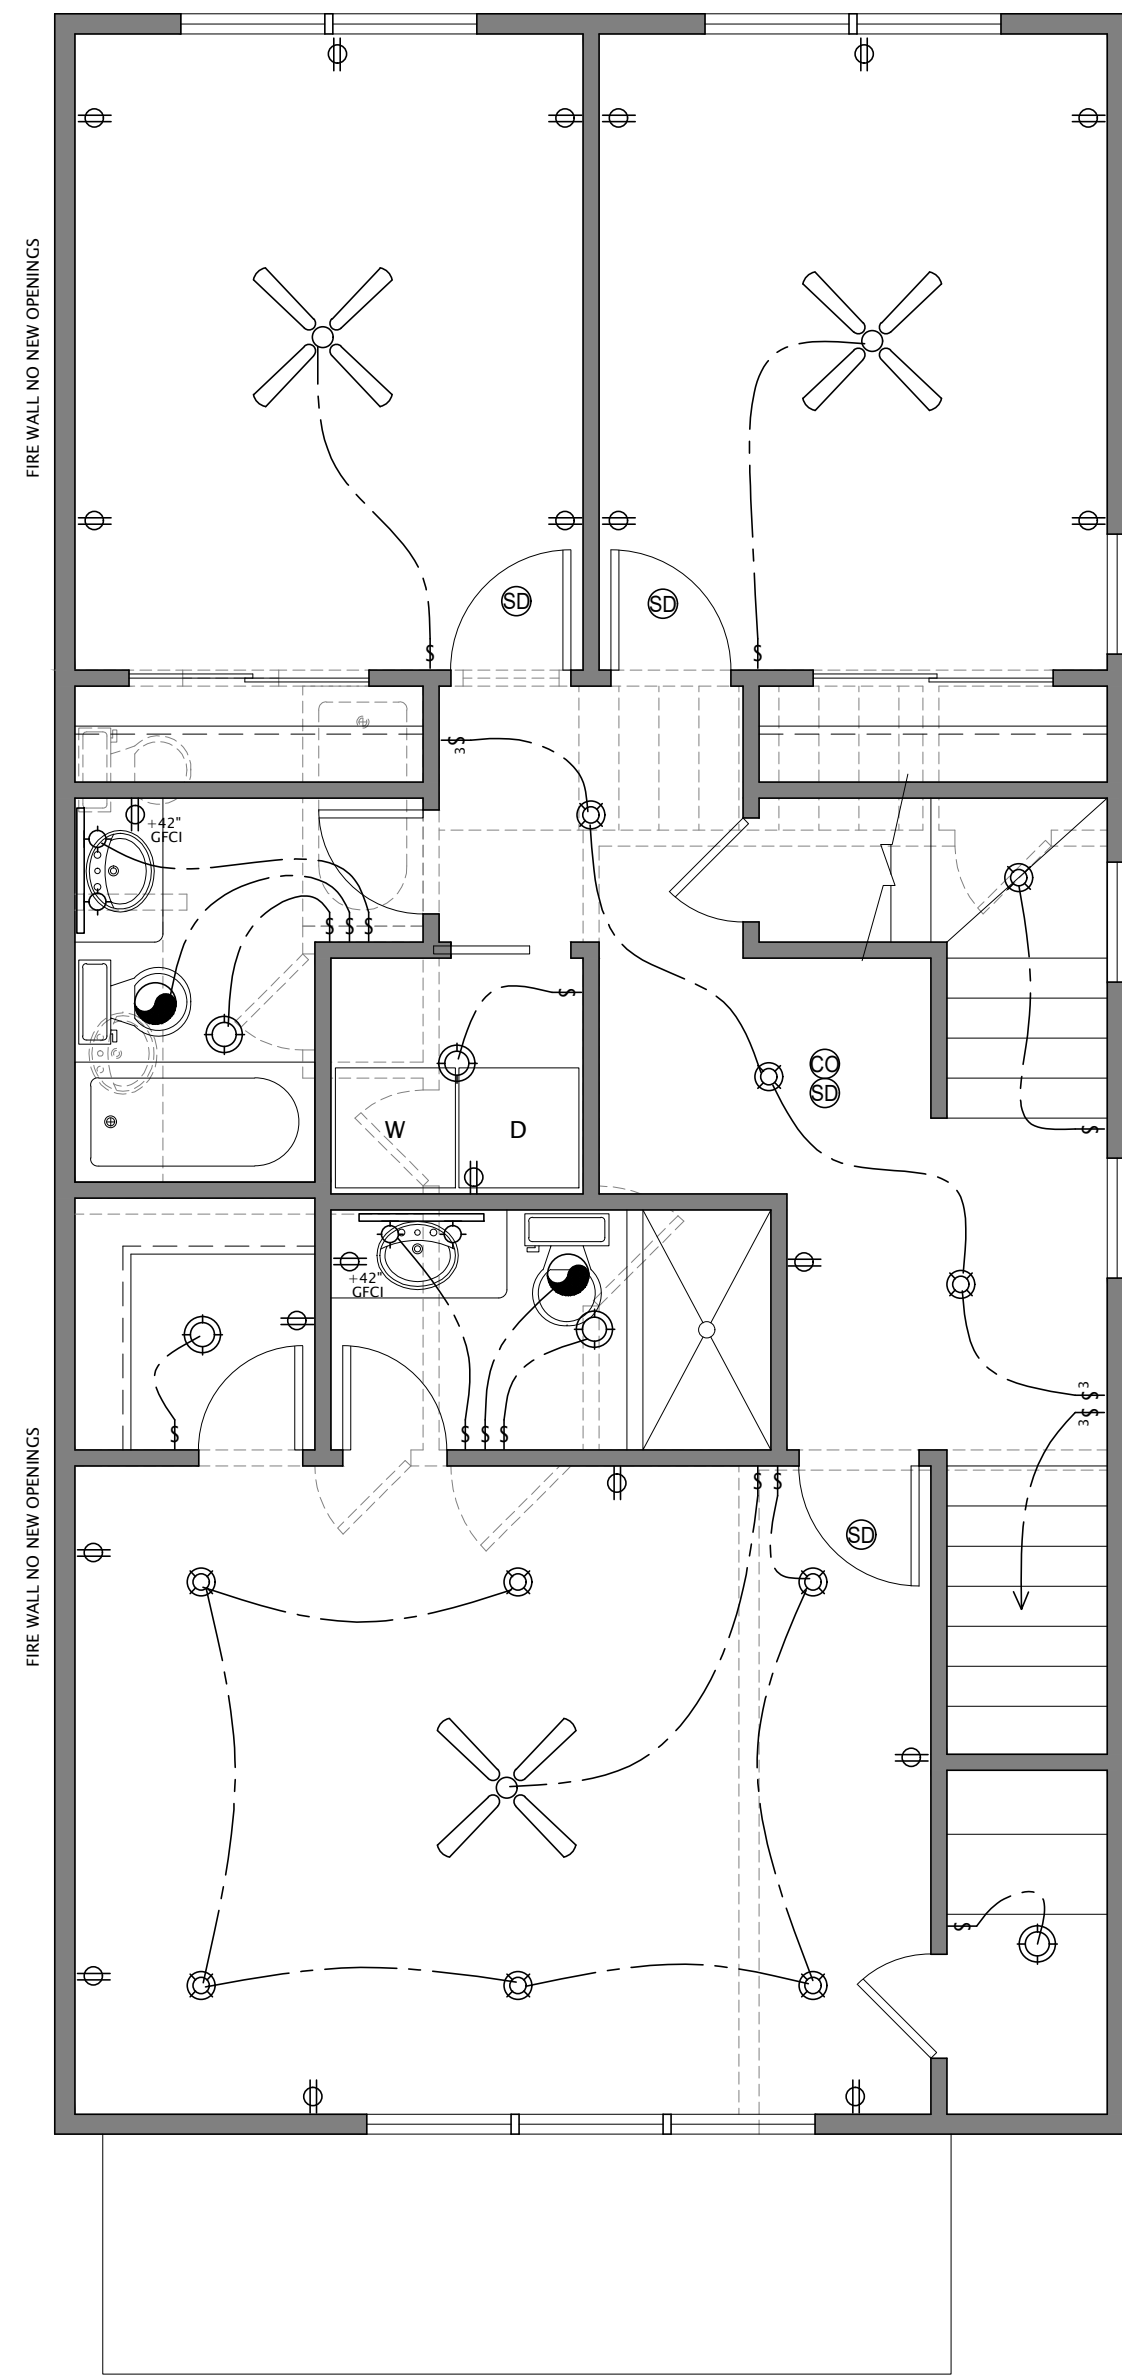

ADDITION & ALTERATION TO:
128 FIRST STREET
KEYPORT, NJ 07735

KINETIC
ARCHITECTS

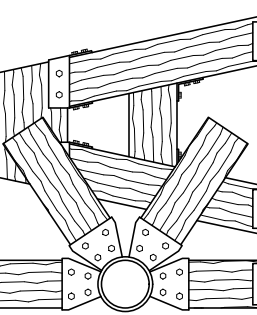

2244 WINFIELD ST.
RAHWAY, NJ
P (732) 910-6178

GJUNKROFT@
KINETICARCHITECTS.COM


Gary Junkroft RA
NJ LIC. # 17679

THE DRAWINGS, SPECIFICATIONS AND OTHER DOCUMENTS PREPARED BY THE ARCHITECT CONSULTANTS FOR THIS PROJECT ARE THE PROPERTY OF KINETIC ARCHITECTS AND ARE NOT TO BE REPRODUCED OR TRANSMITTED IN ANY FORM OR BY ANY MEANS, ELECTRONIC OR MECHANICAL, INCLUDING PHOTOCOPYING, RECORDING, OR BY ANY INFORMATION STORAGE AND RETRIEVAL SYSTEM, WITHOUT THE WRITTEN PERMISSION OF KINETIC ARCHITECTS. THE ARCHITECT CONSULTANTS SHALL NOT BE RESPONSIBLE FOR ANY ERRORS OR OMISSIONS IN THE DRAWINGS, SPECIFICATIONS OR OTHER DOCUMENTS. THE ARCHITECT CONSULTANTS SHALL NOT BE RESPONSIBLE FOR ANY CONSTRUCTION DEFECTS OR OMISSIONS IN THE PROJECT. THE ARCHITECT CONSULTANTS DRAWINGS SHALL BE FOR ADDITIONS TO THIS PROJECT OR FOR COMPLETION OF THIS PROJECT BY OTHERS.

ELECTRIC PLANS

DATE: 01/08/23
DRAWN BY: GAJ
CHECKED BY: GAJ
JOB # 21-256

A-4
4 OF 5

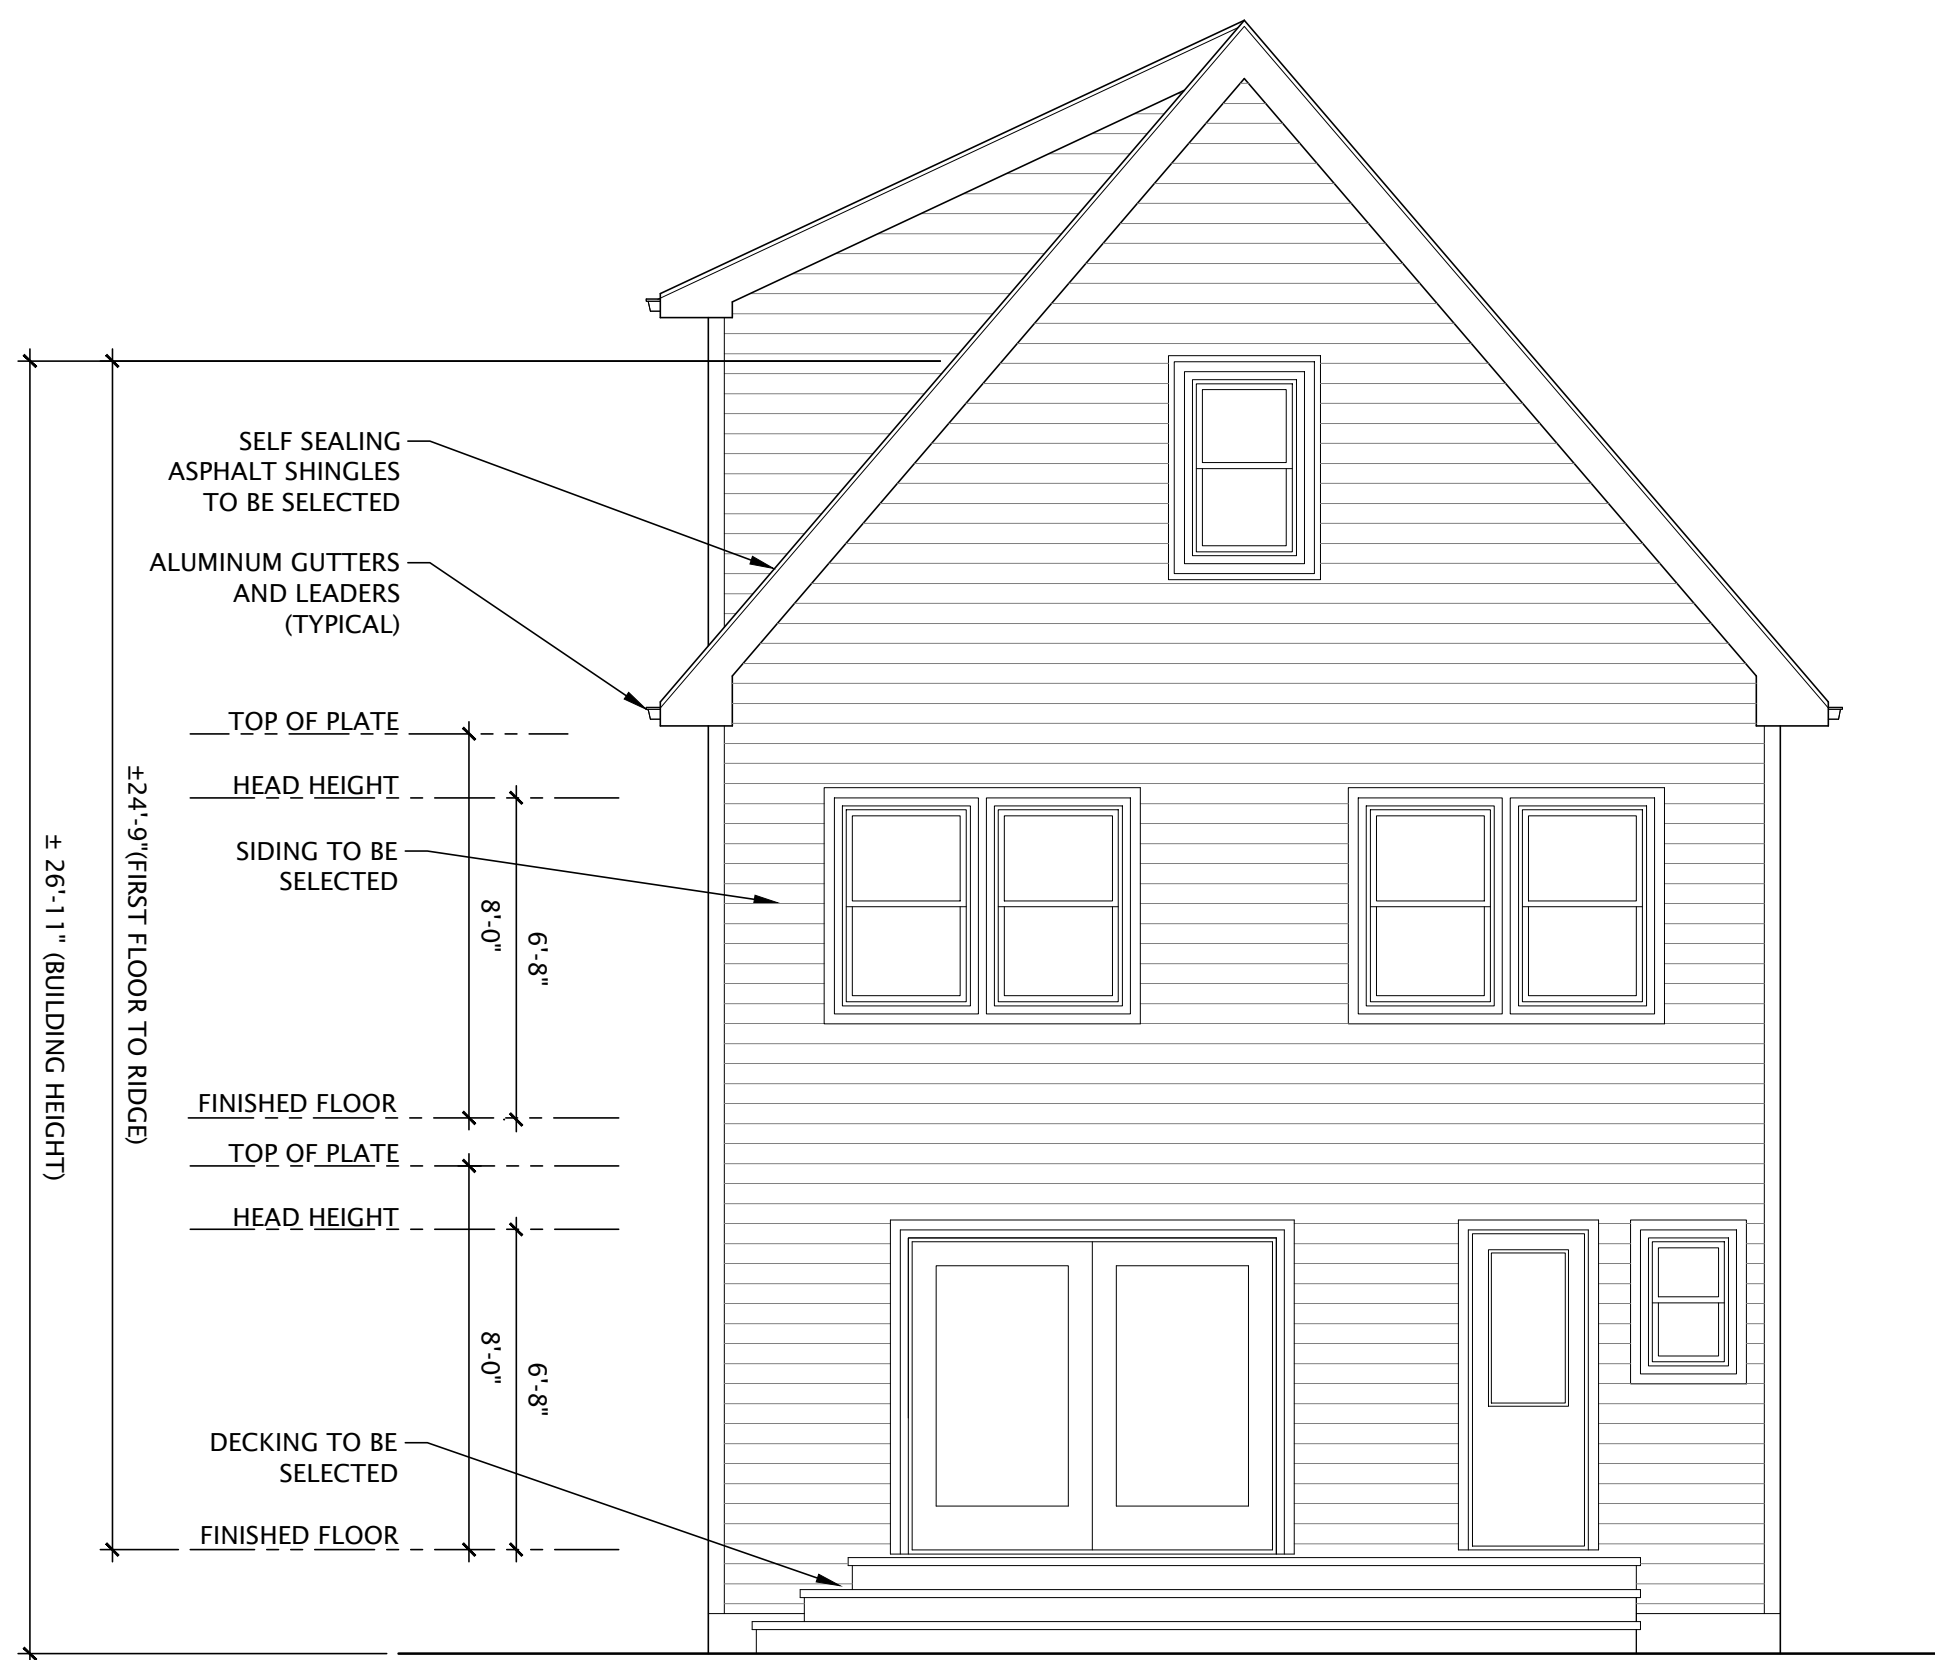

REAR ELEVATION

SCALE = 1/4"=1'-0"



LEFT SIDE ELEVATION

SCALE = 1/4"=1'-0"



RIGHT SIDE ELEVATION

SCALE = 1/4"=1'-0"




FRONT ELEVATION

SCALE = 1/4"=1'-0"


ADDITION & ALTERATION TO;
128 FIRST STREET
KEYPORT, NJ 07735

KINETIC
ARCHITECTS

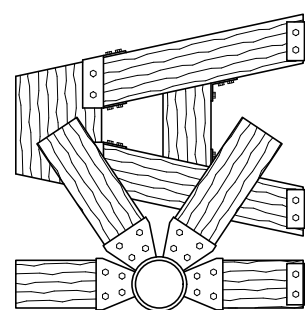

2244 WINFIELD ST.
RAHWAY, NJ
P (732) 910-6178

GJUNKROFT@
KINETICARCHITECTS.COM

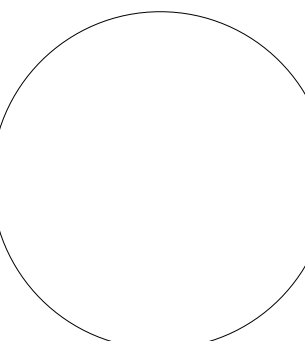

Gary Junkroft RA
NJ LIC. # 17679

THE DRAWINGS, SPECIFICATIONS AND OTHER DOCUMENTS PREPARED BY THE ARCHITECT CONSULTANTS FOR THIS PROJECT ARE TO BE USED ONLY FOR THE PROJECT AND NOT FOR ANY OTHER PROJECT. THE ARCHITECT CONSULTANTS SHALL NOT BE RESPONSIBLE FOR ANY ERRORS OR OMISSIONS IN THE DRAWINGS, SPECIFICATIONS AND OTHER DOCUMENTS. THE ARCHITECT CONSULTANTS SHALL NOT BE RESPONSIBLE FOR ANY CHANGES TO THE PROJECT WITHOUT THE WRITTEN CONSENT OF THE ARCHITECT CONSULTANTS. THE ARCHITECT CONSULTANTS SHALL NOT BE RESPONSIBLE FOR ANY CHANGES TO THE PROJECT WITHOUT THE WRITTEN CONSENT OF THE ARCHITECT CONSULTANTS.

ELEVATIONS

DATE: 01/08/23
DRAWN BY: GAJ
CHECKED BY: GAJ
JOB # 21-256

A-5
5 OF 5